


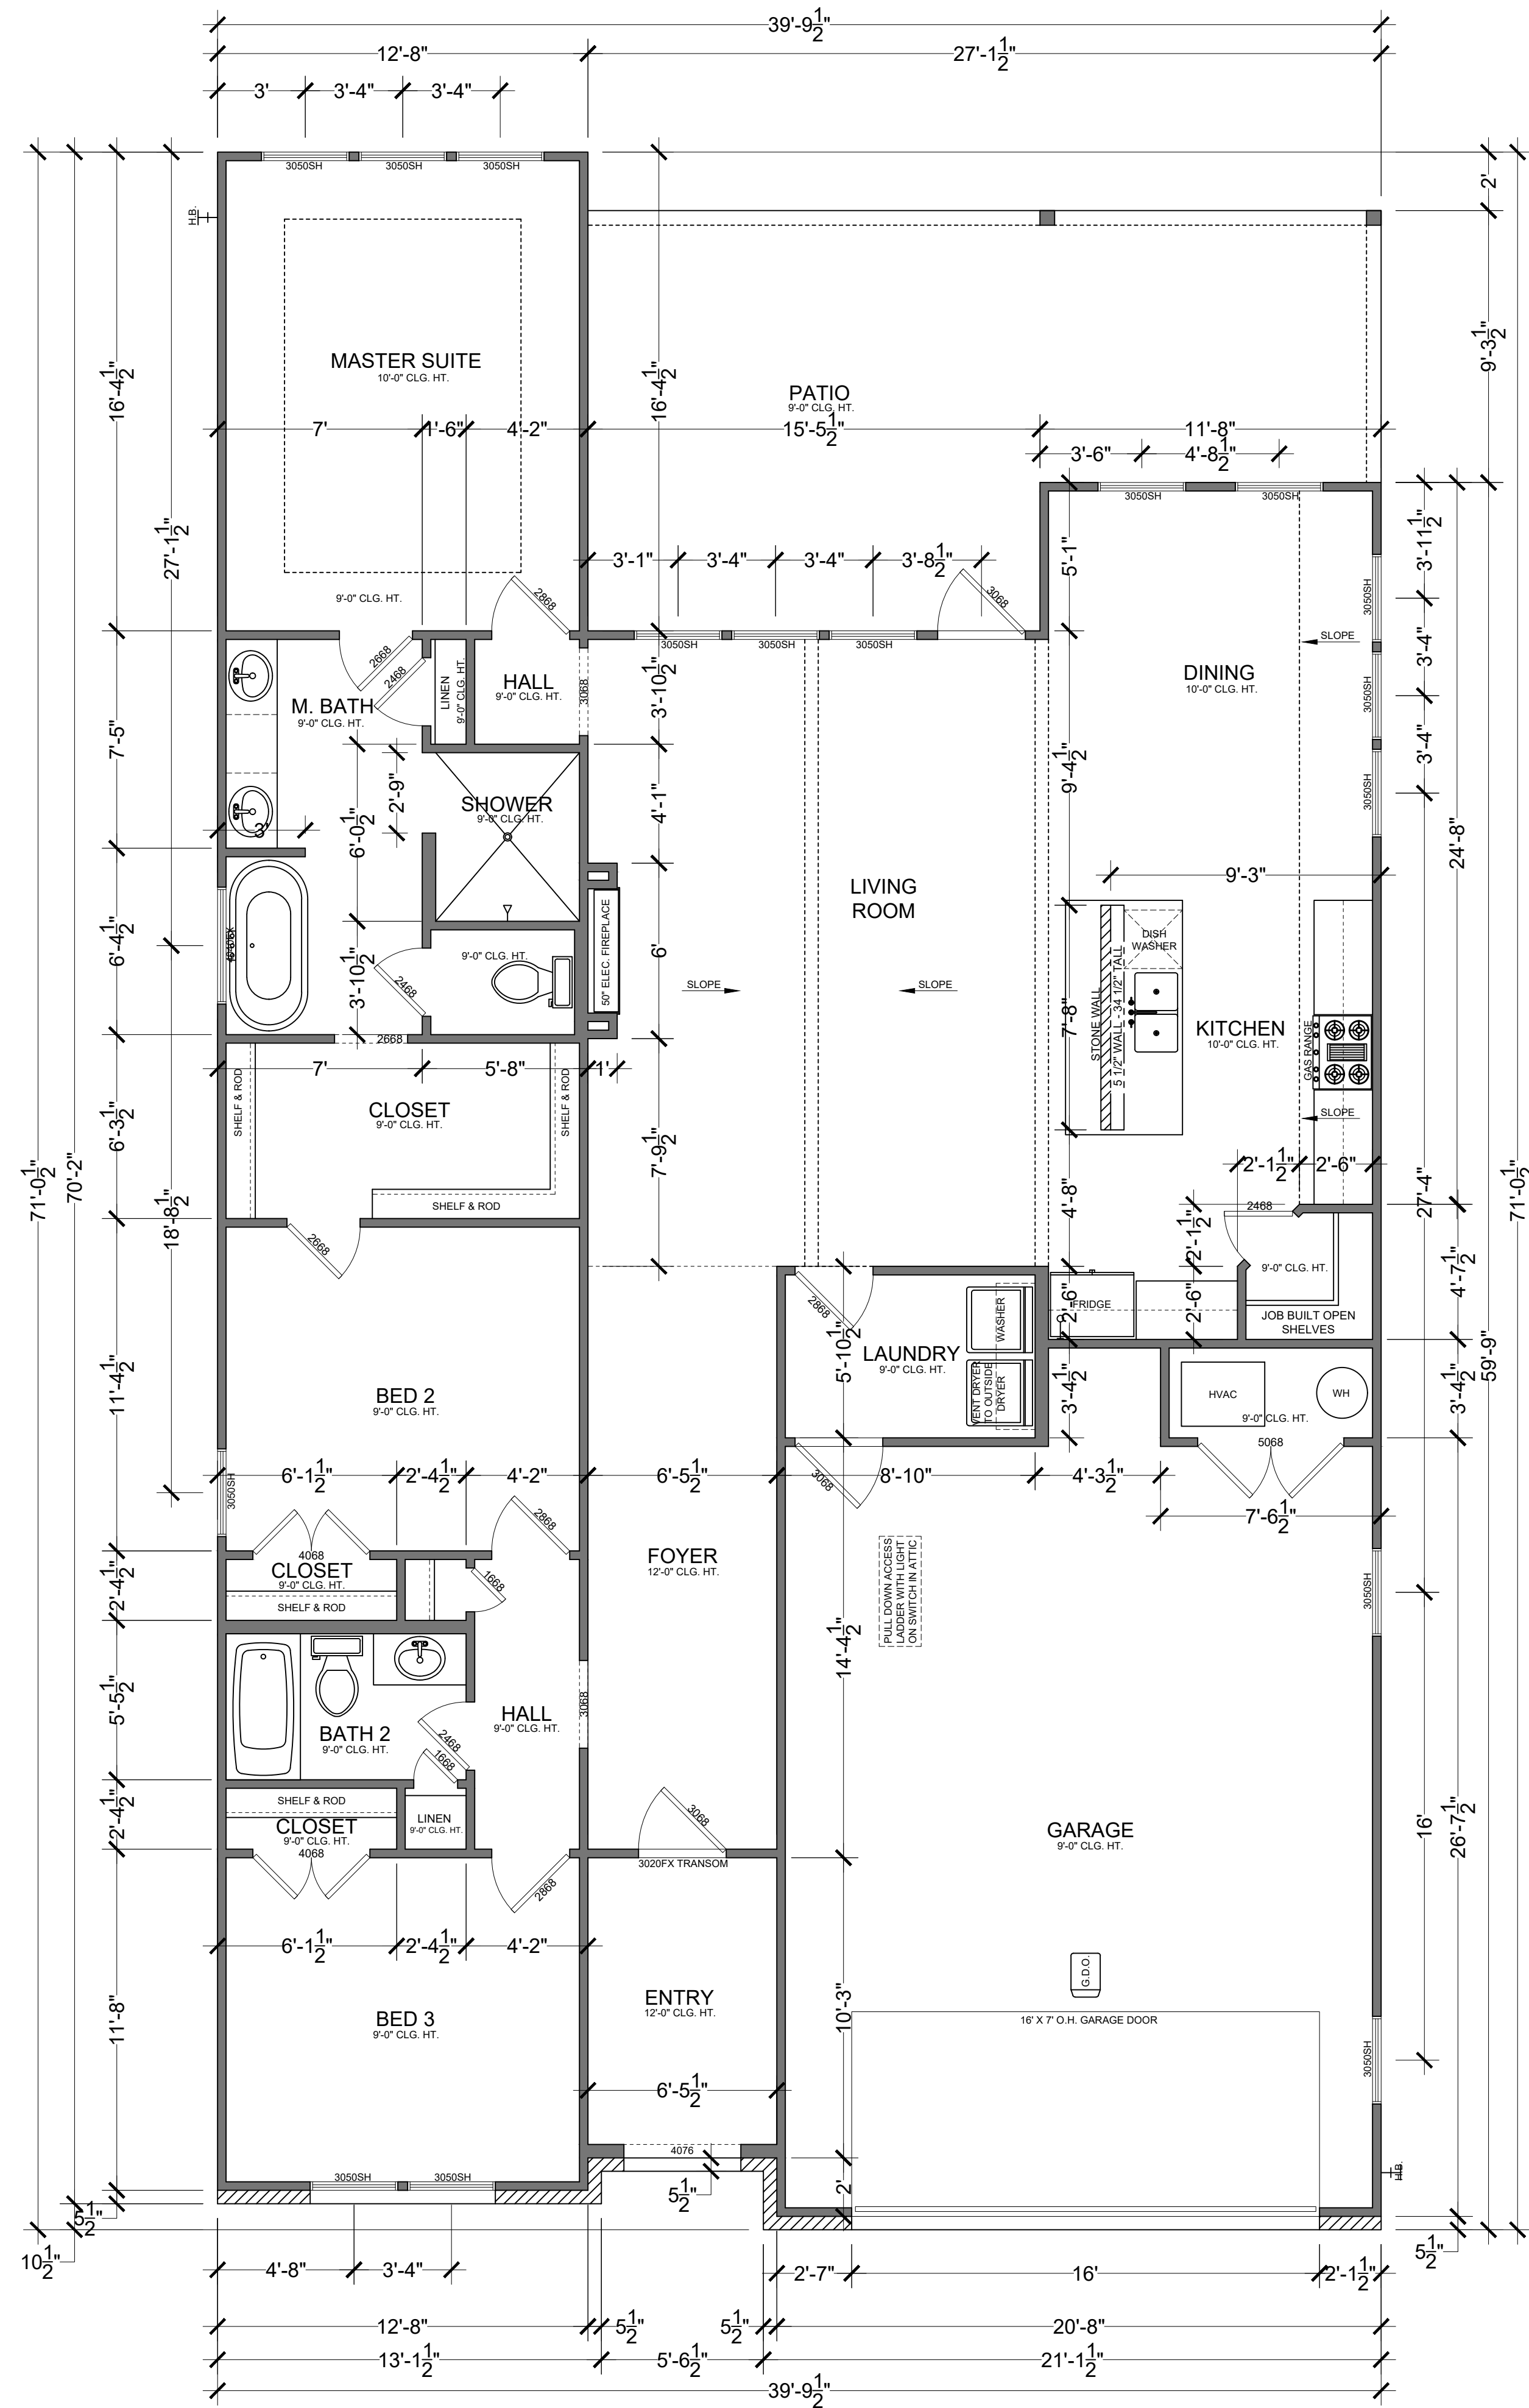

SQUARE FOOTAGE	
LIVABLE	1755 SQ. FT.
FRONT PORCH	66 SQ. FT.
BACK PORCH	331 SQ. FT.
GARAGE	579 SQ. FT.
TOTAL SLAB	2750 SQ. FT.

FLOOR PLAN

SCALE: 1/4" = 1'-0"



Heritage Crafted Homes

No.	Revision/Issue	Date
-----	----------------	------

Firm Name and Address

Heritage Crafted homes
200 SE Loop 410, Ste 108
San Antonio, TX 78220

Project Name and Address

Jose Charo
1315 E. Pyron Av.
San Antonio, TX 78214

Project Charo	Sheet 1 of 6
Date 07/30/25	
Scale 1/4" = 1'-0"	




Heritage Crafted Homes

No.	Revision/Issue	Date

Firm Name and Address
Heritage Crafted homes
200 SE Loop 410, Ste 108
San Antonio, TX 78220

Project Name and Address
Jose Charo
1315 E. Pyron Av.
San Antonio, TX 78214


Project Charo	Sheet 2 of 6
Date 07/30/25	
Scale 1/4" = 1'-0"	

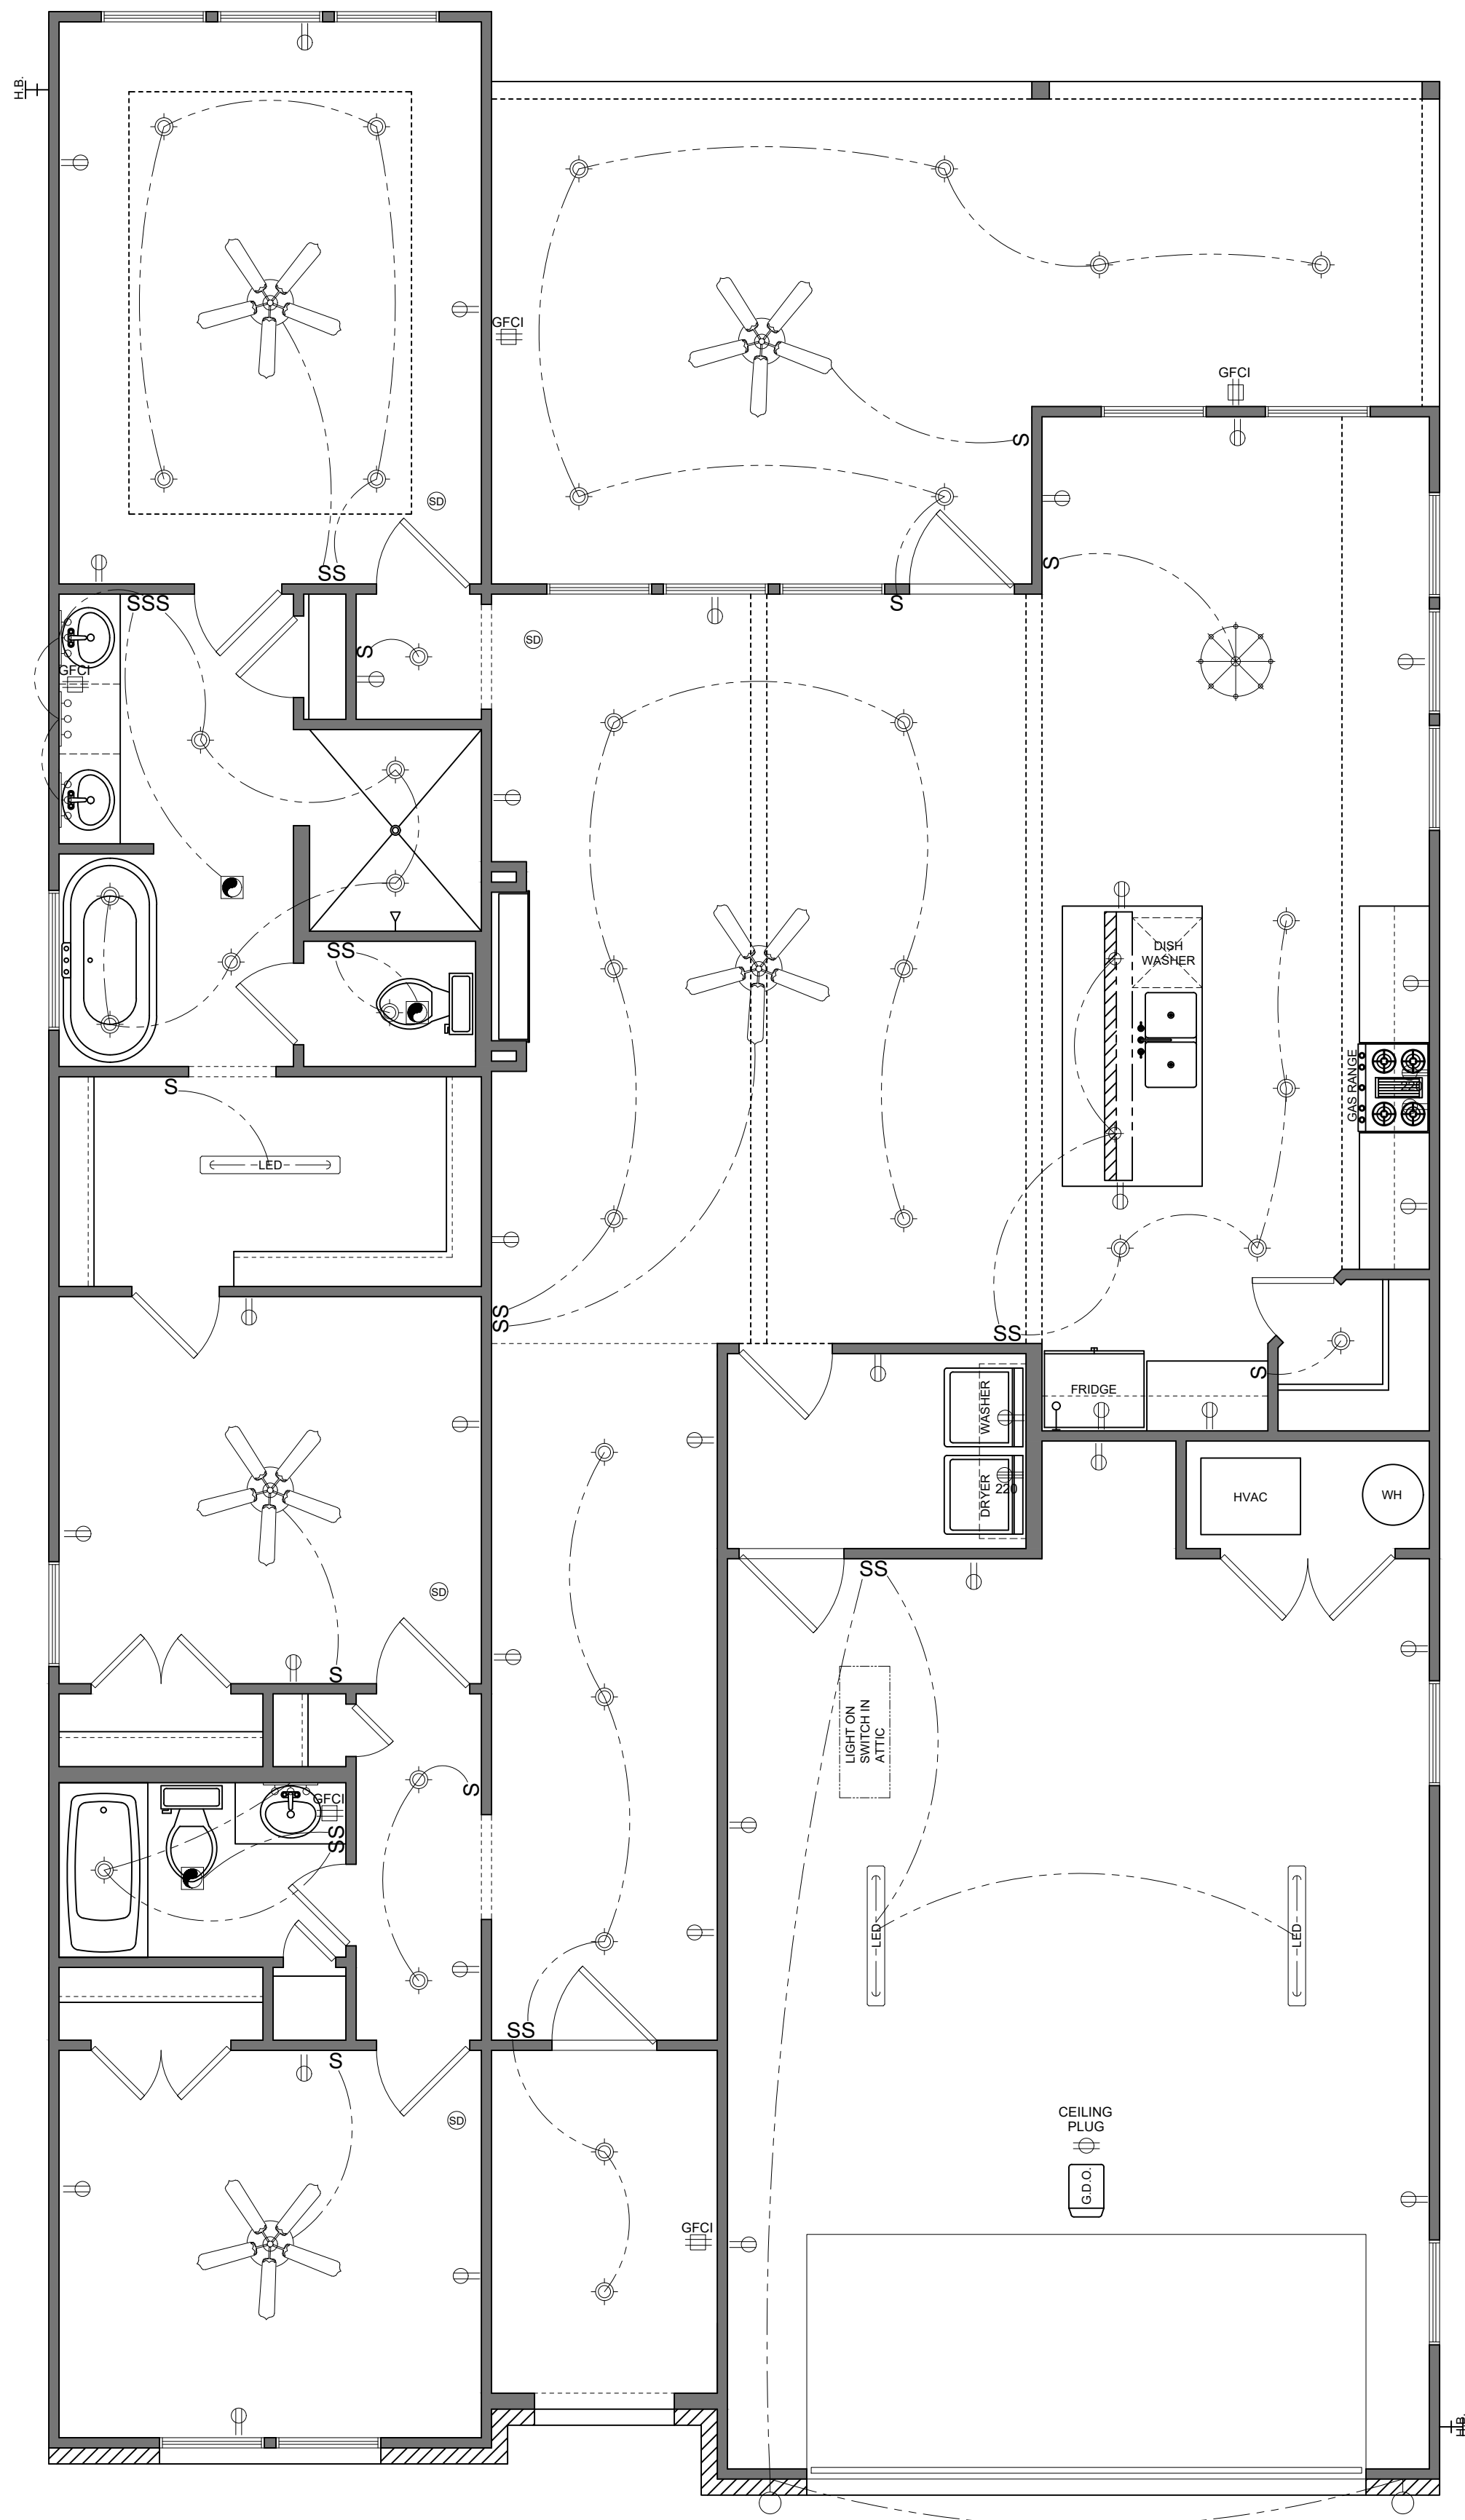

- 110 V CONC DUPLEX OUTLET
- 220 V OUTLET
- SURFACE MOUNT FOR LIGHT OR FAN
- CAN LIGHT
- WALL MOUNT FOR LIGHT FIXTURE
- GROUND FAULT INTERRUPTED DUPLEX OUTLET
- WALL MOUNT FOR MULTI LIGHT FIXTURE
- HANGING PENDENT LIGHT
- EXHAUST FAN - 50 CFM MIN VENT OUTSIDE
- SINGLE SWITCH
- SMOKE DETECTOR

ELECTRICAL PLAN

 SCALE: 1/4" = 1'-0"






Heritage Crafted Homes

No.	Revision/Issue	Date

Firm Name and Address
Heritage Crafted homes
200 SE Loop 410, Ste 108
San Antonio, TX 78220


Project Name and Address
Jose Charo
1315 E. Pyron Av.
San Antonio, TX 78214


Project Charo	Sheet 3 of 6
Date 07/30/25	
Scale 1/4" = 1'-0"	

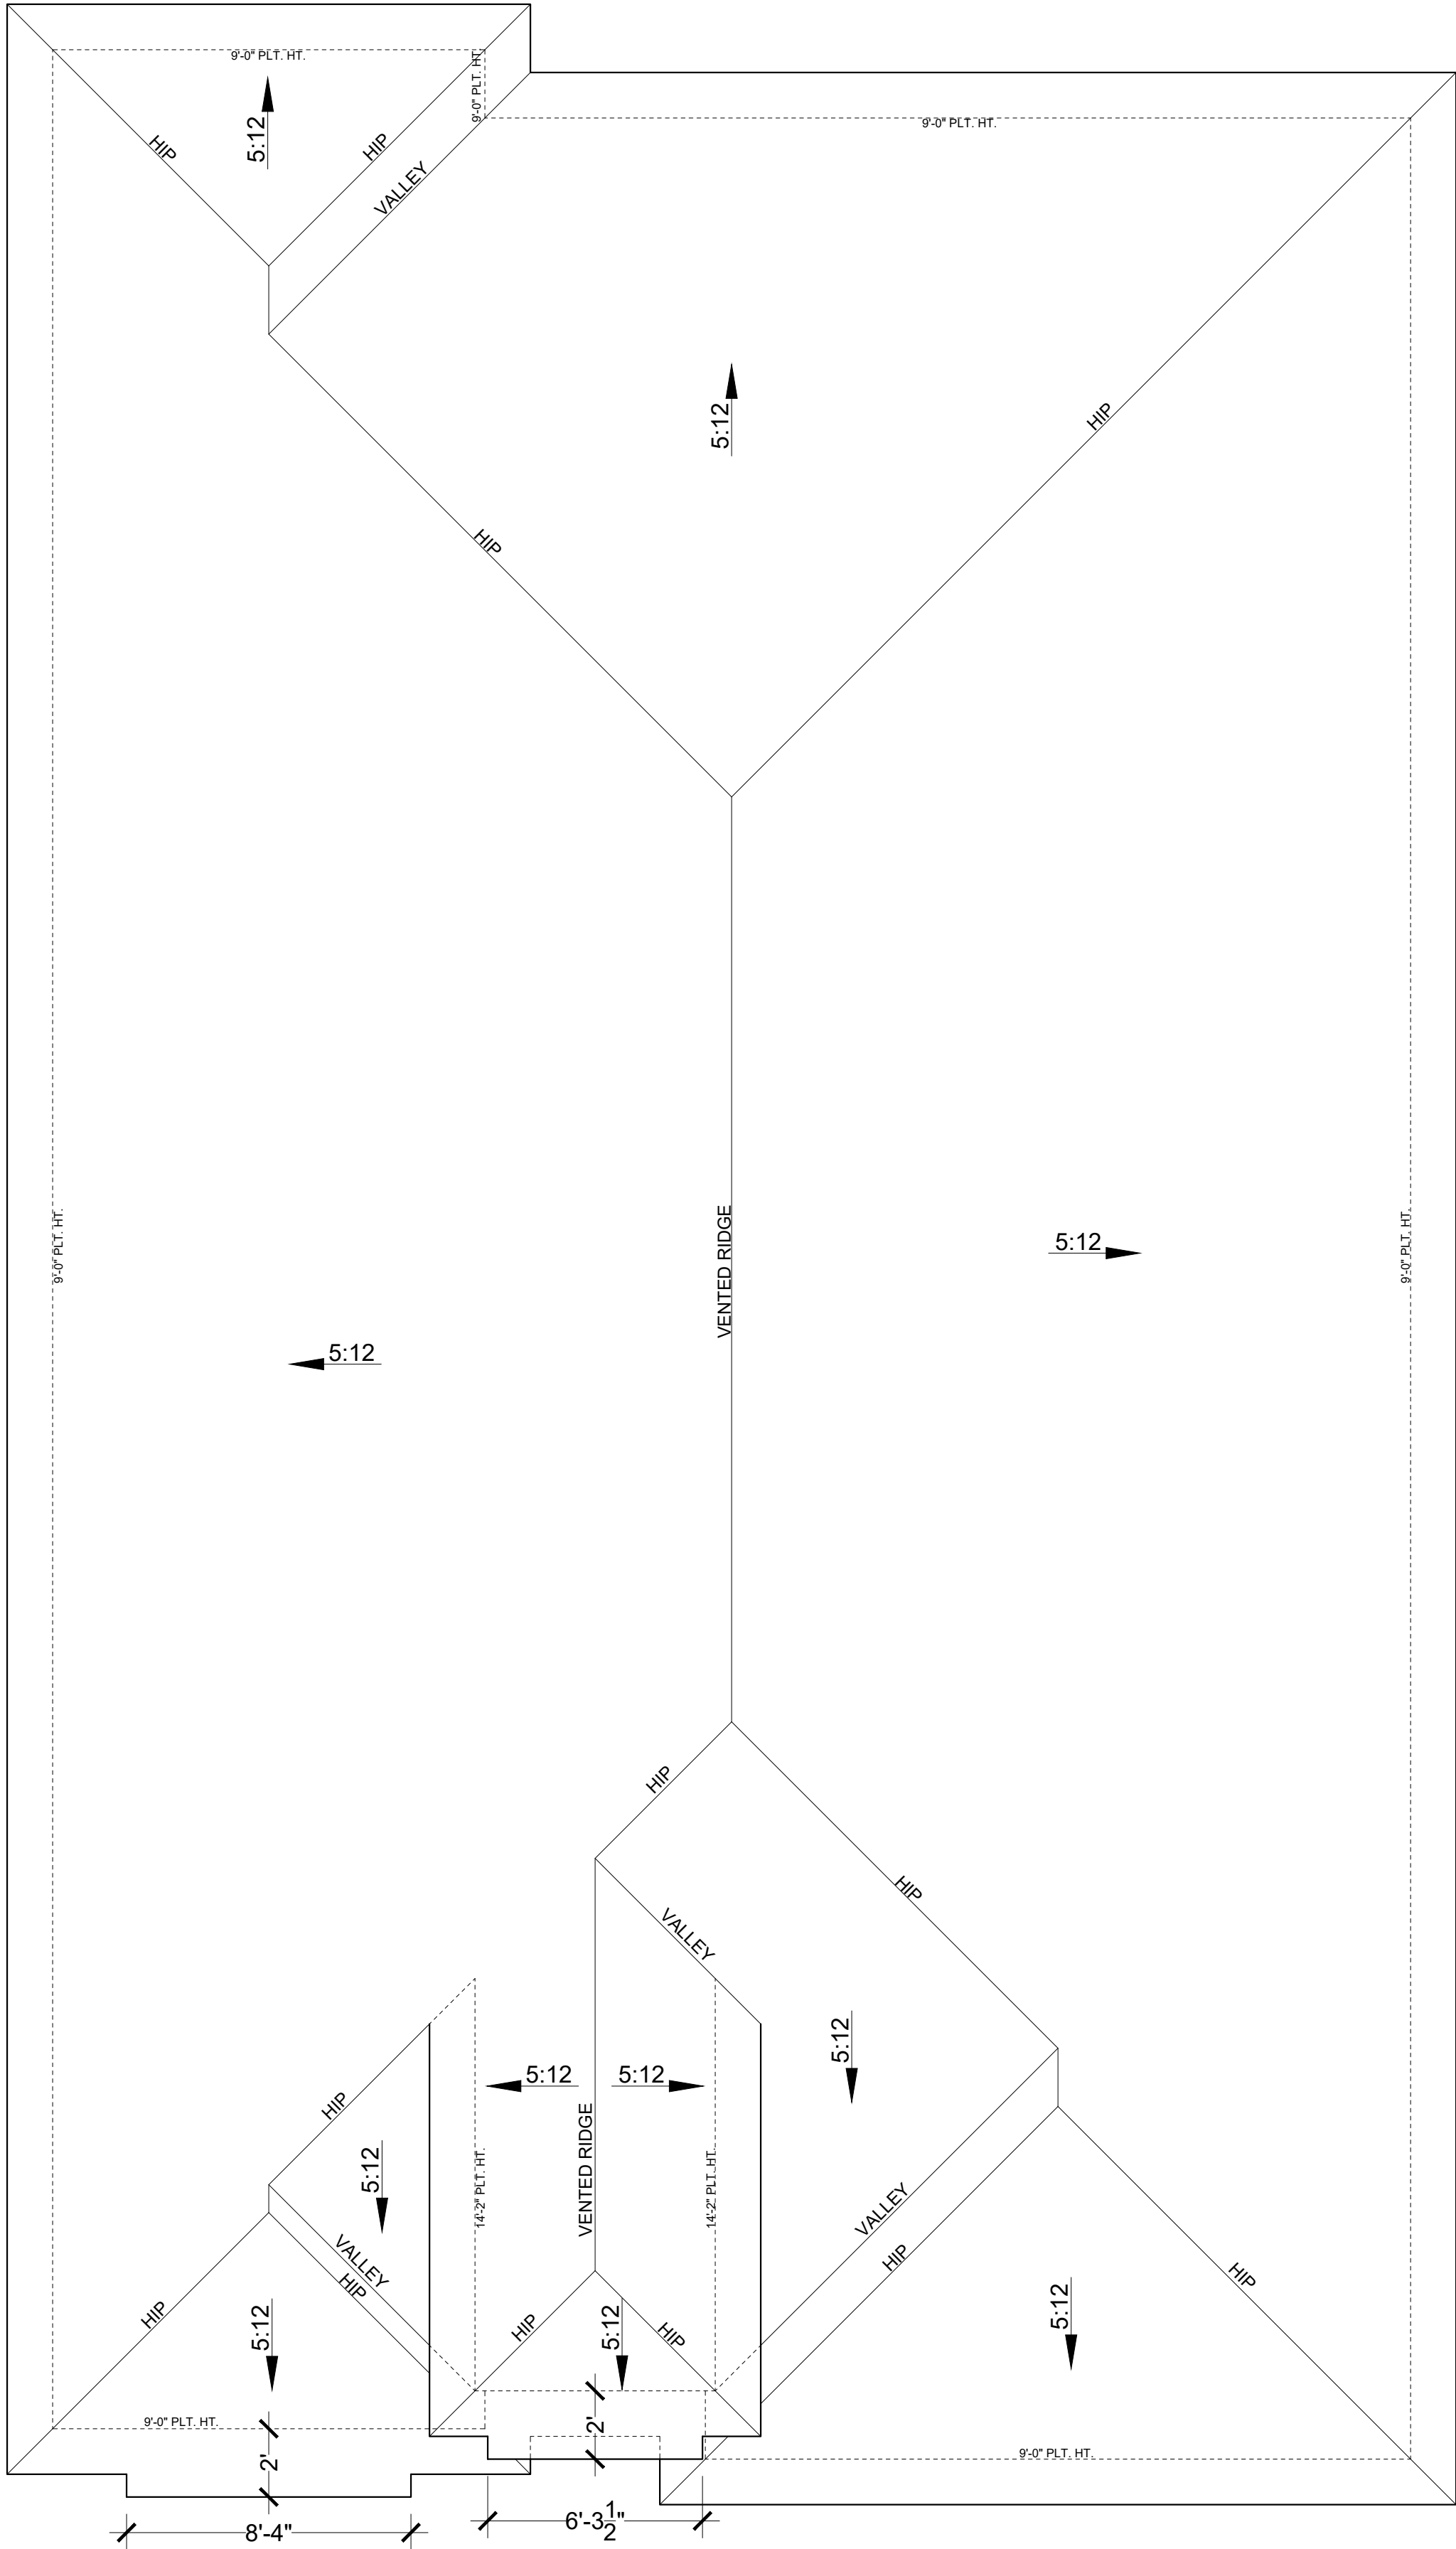


ROOF PLAN

 SCALE: 1/4" = 1'-0"




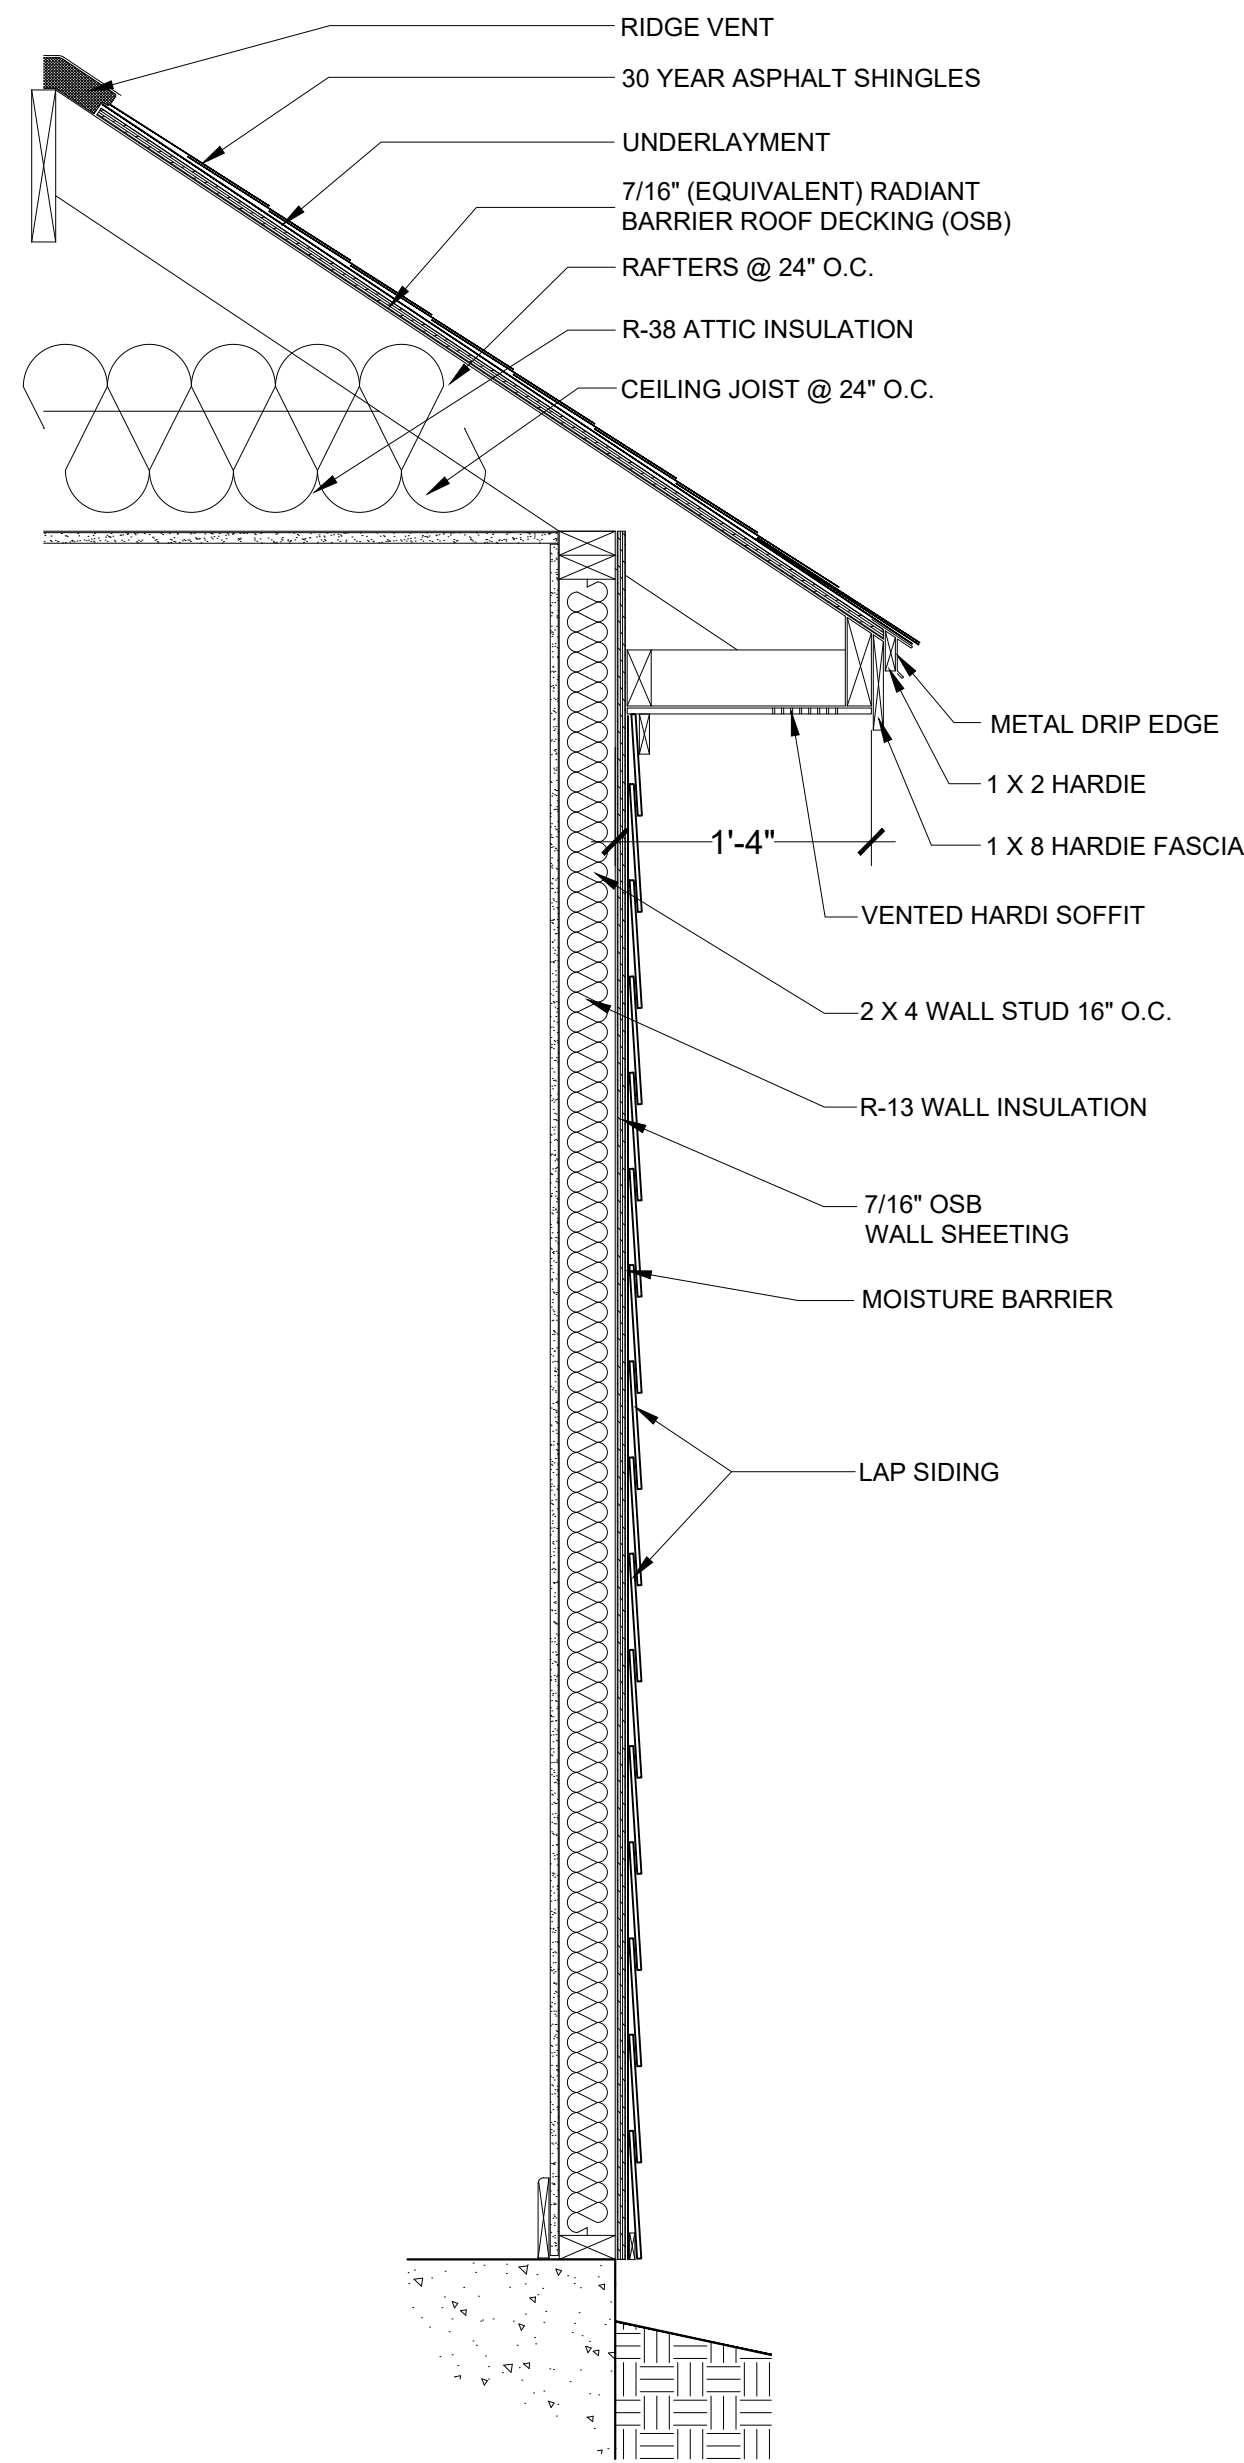


TYPICAL WALL SECTION:
SCALE: 1" = 1'-0"

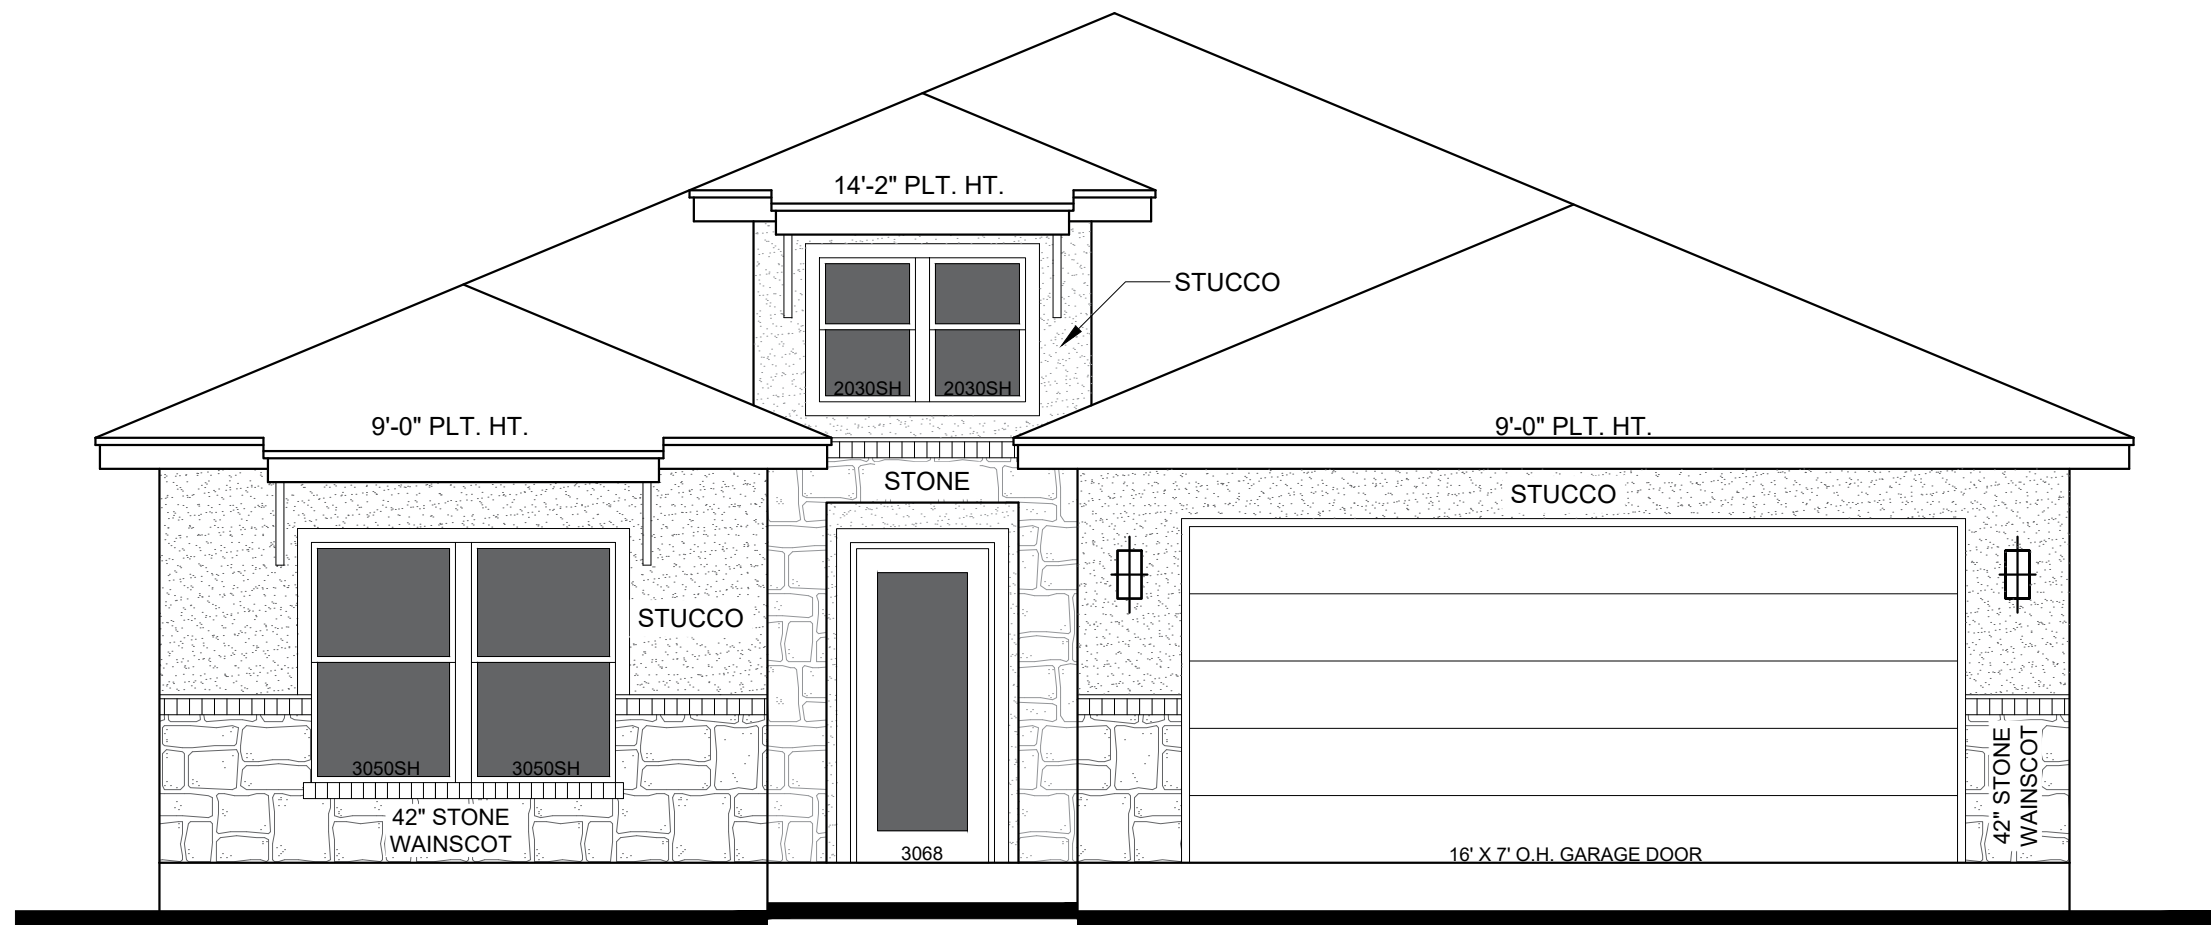

FRONT ELEVATION:

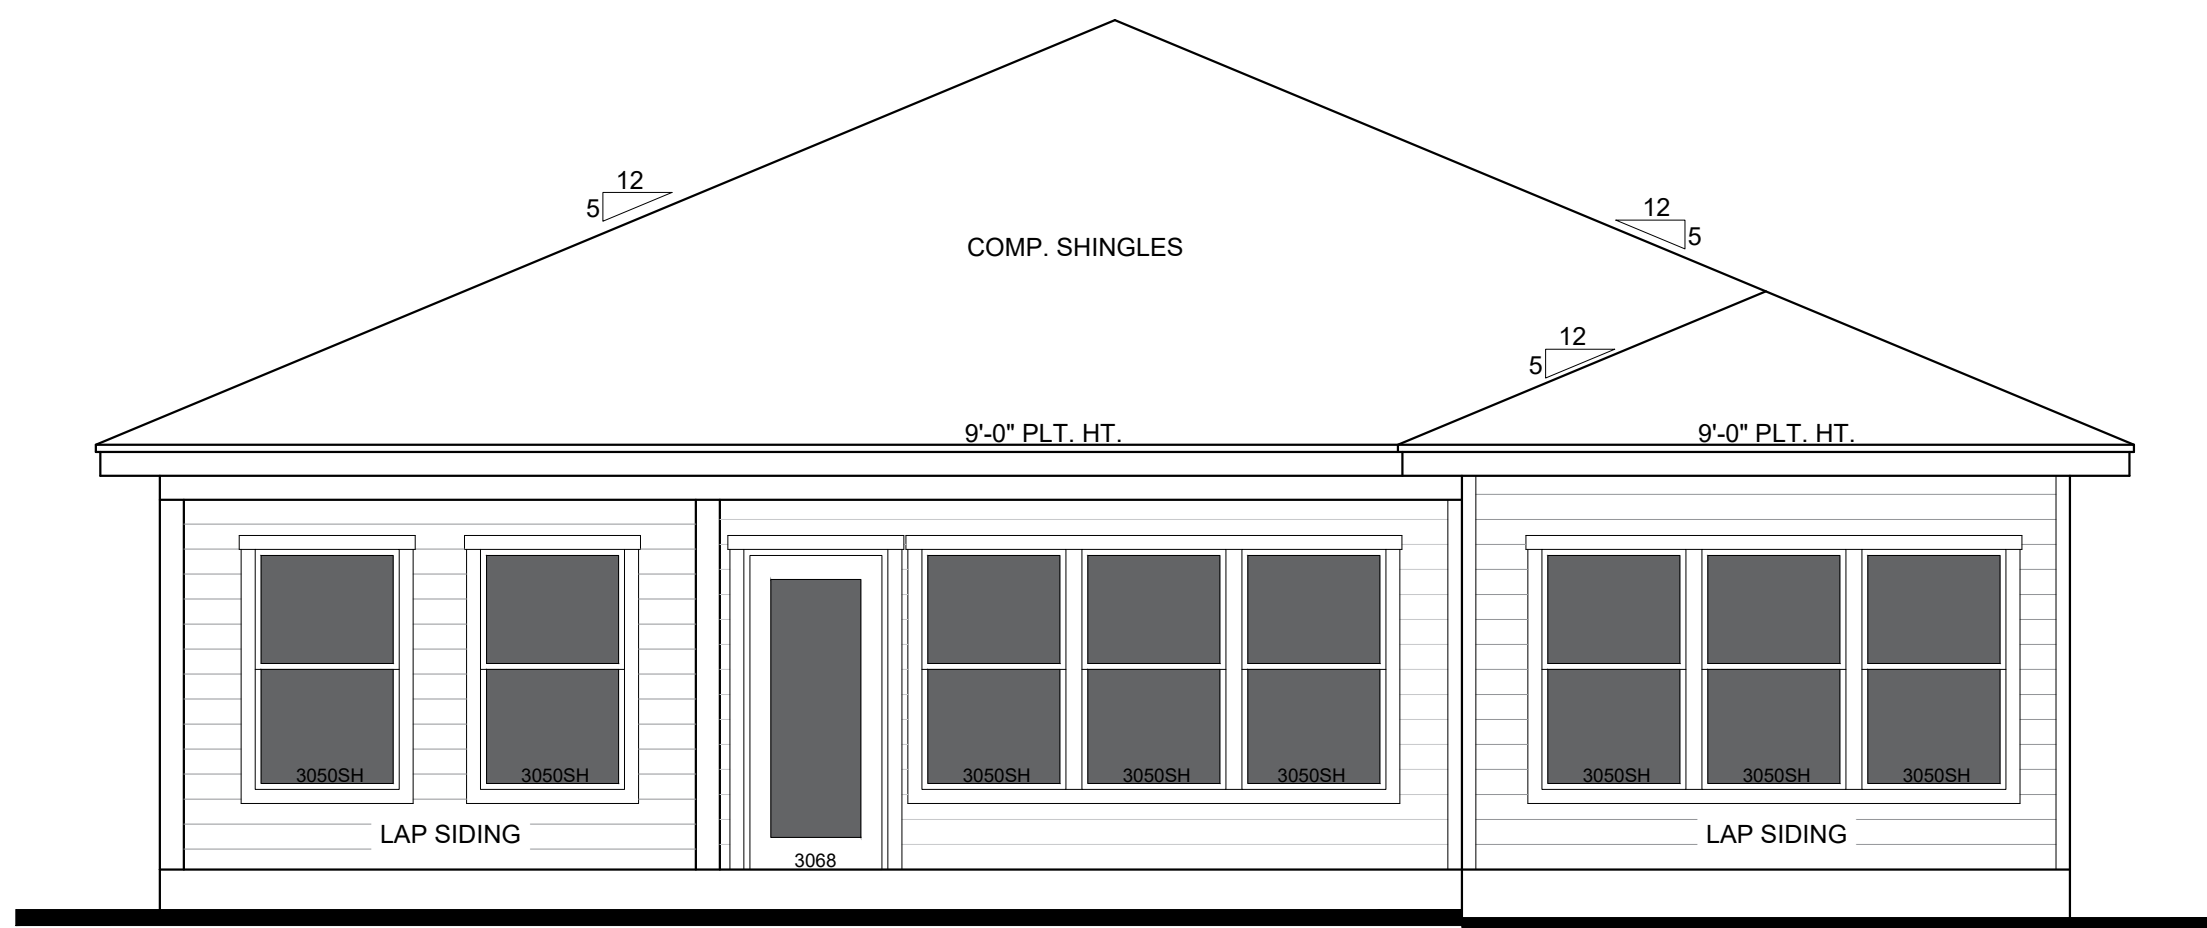

REAR ELEVATION:

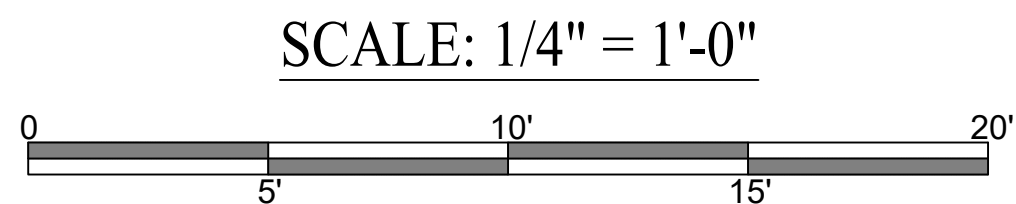

Heritage Crafted Homes

No.	Revision/Issue	Date

Firm Name and Address
Heritage Crafted homes
200 SE Loop 410, Ste 108
San Antonio, TX 78220

Project Name and Address
Jose Charo
1315 E. Pyron Av.
San Antonio, TX 78214

Project Charo	Sheet 4 of 6
Date 07/30/25	
Scale 1/4" = 1'-0"	




Heritage Crafted Homes

No.	Revision/Issue	Date


Firm Name and Address
Heritage Crafted homes
200 SE Loop 410, Ste 108
San Antonio, TX 78220

Project Name and Address
Jose Charo
1315 E. Pyron Av.
San Antonio, TX 78214


Project Charo	Sheet 5 of 6
Date 07/30/25	
Scale 1/4" = 1'-0"	

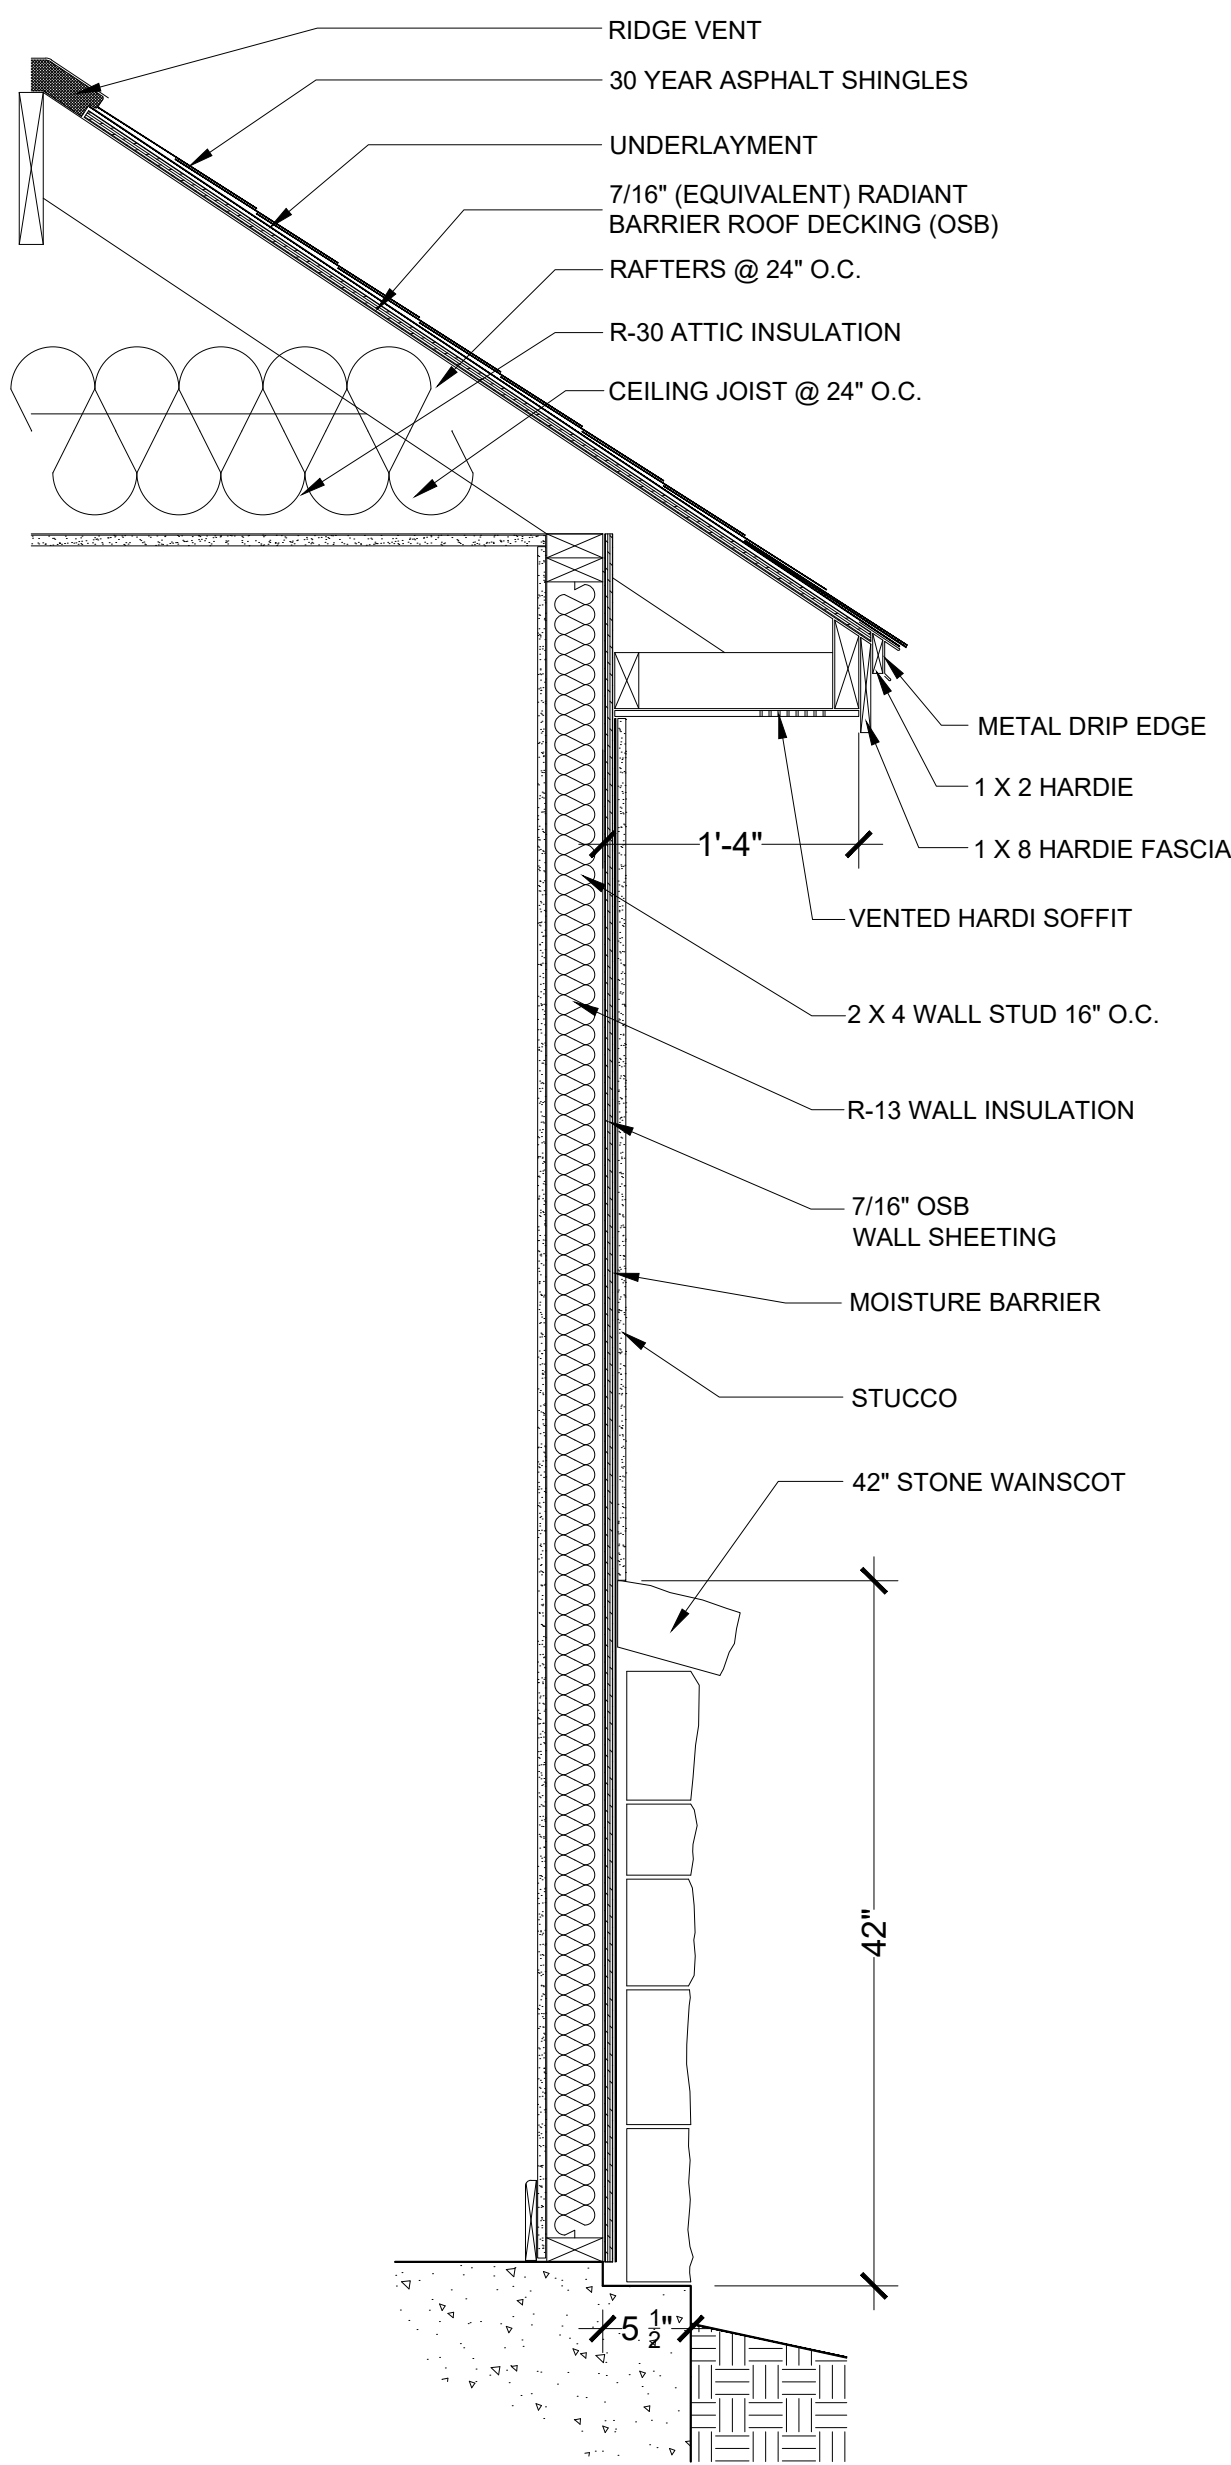


TYPICAL WALL SECTION:
SCALE: 1" = 1'-0"





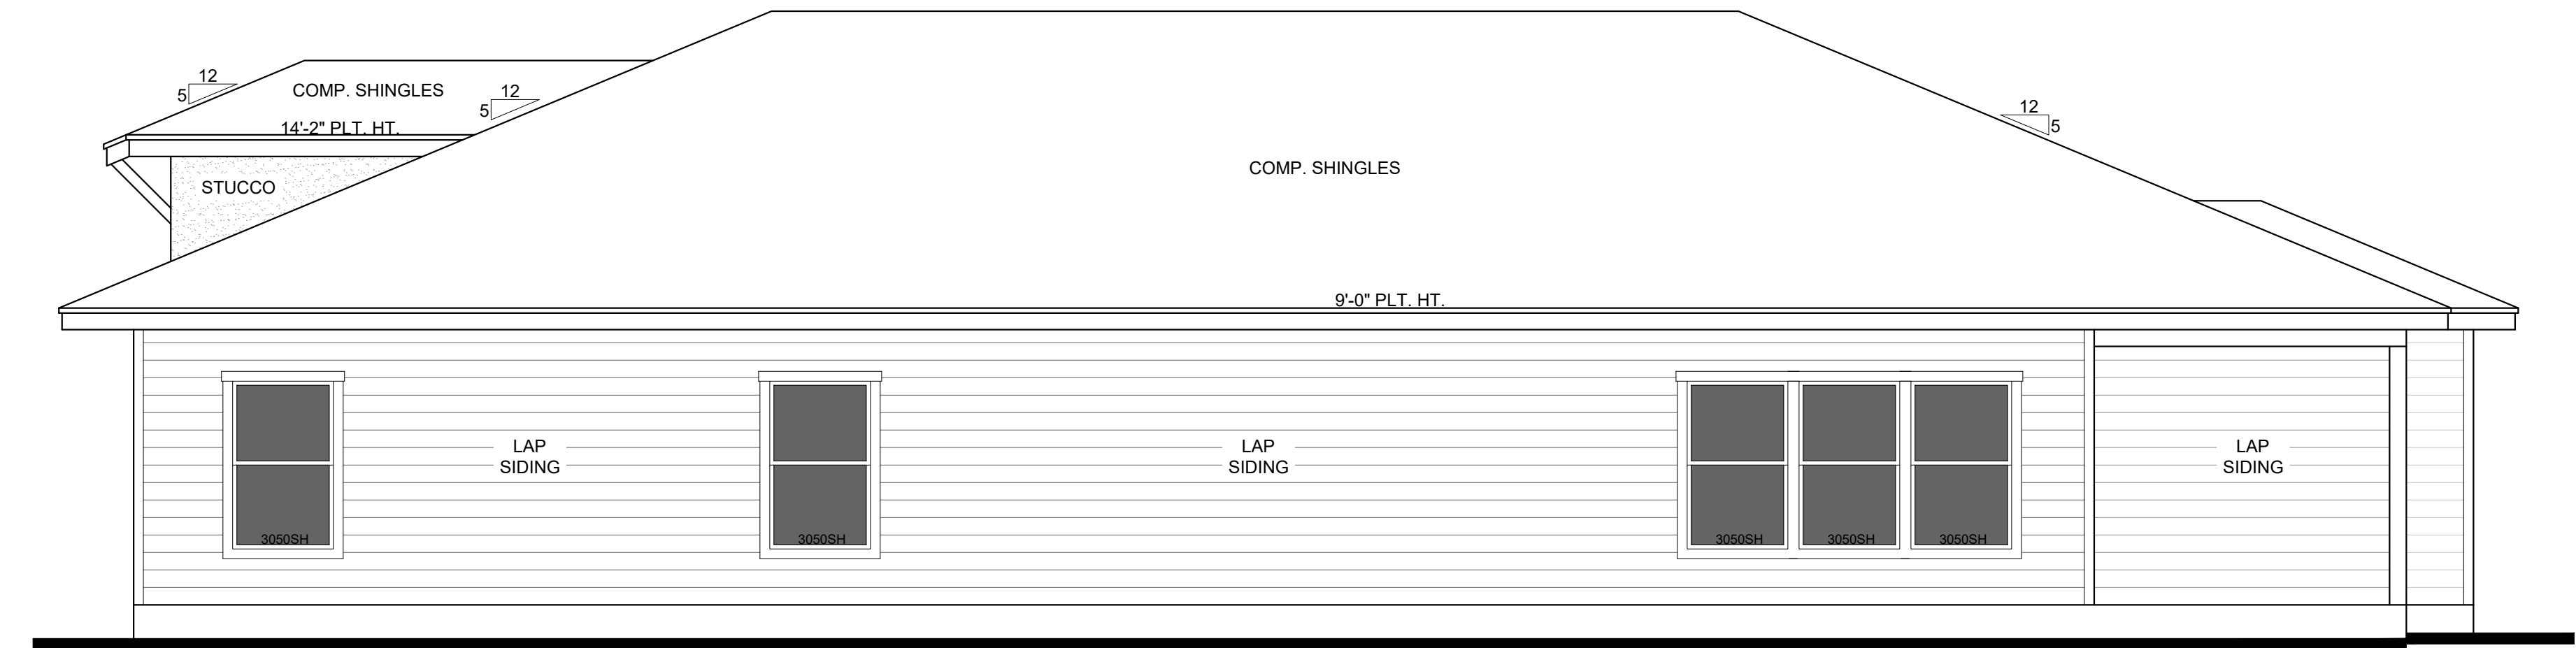


LEFT ELEVATION:

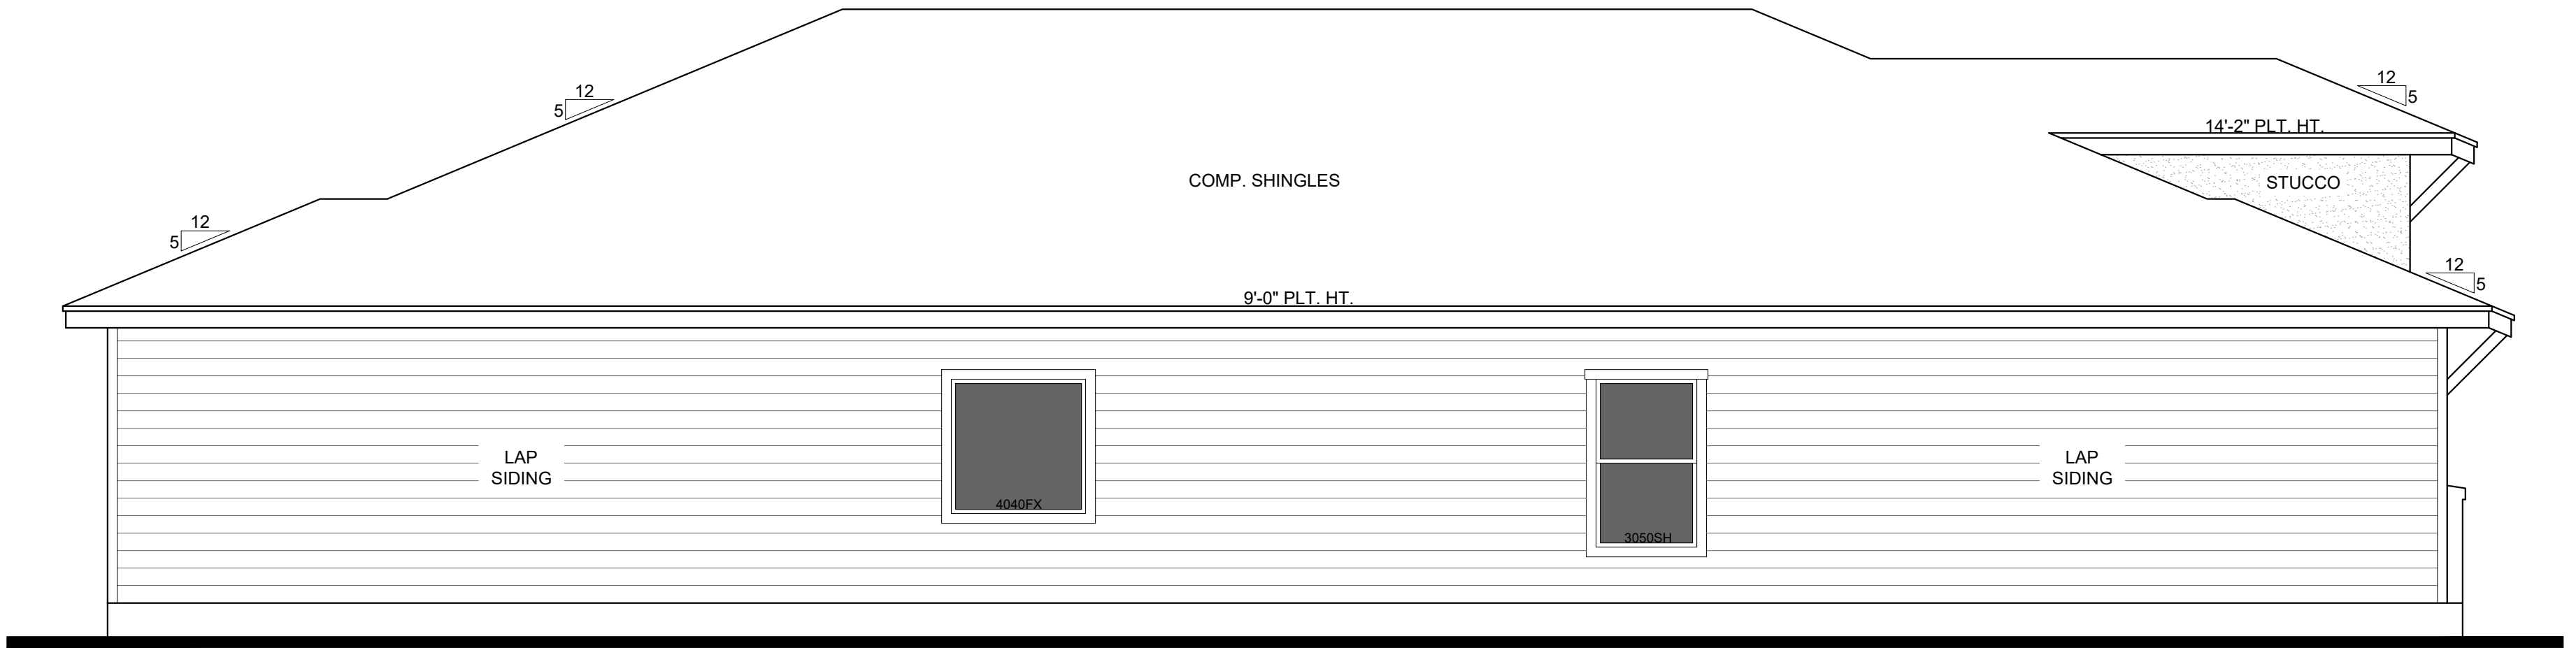

RIGHT ELEVATION:

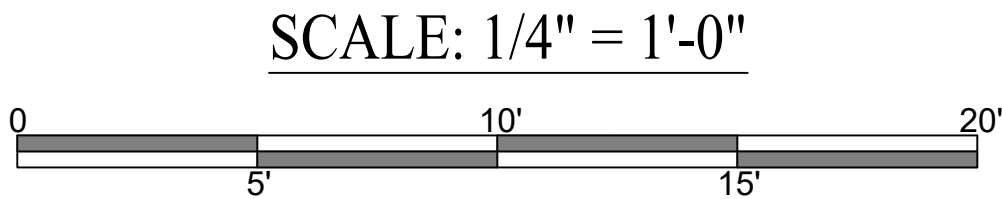

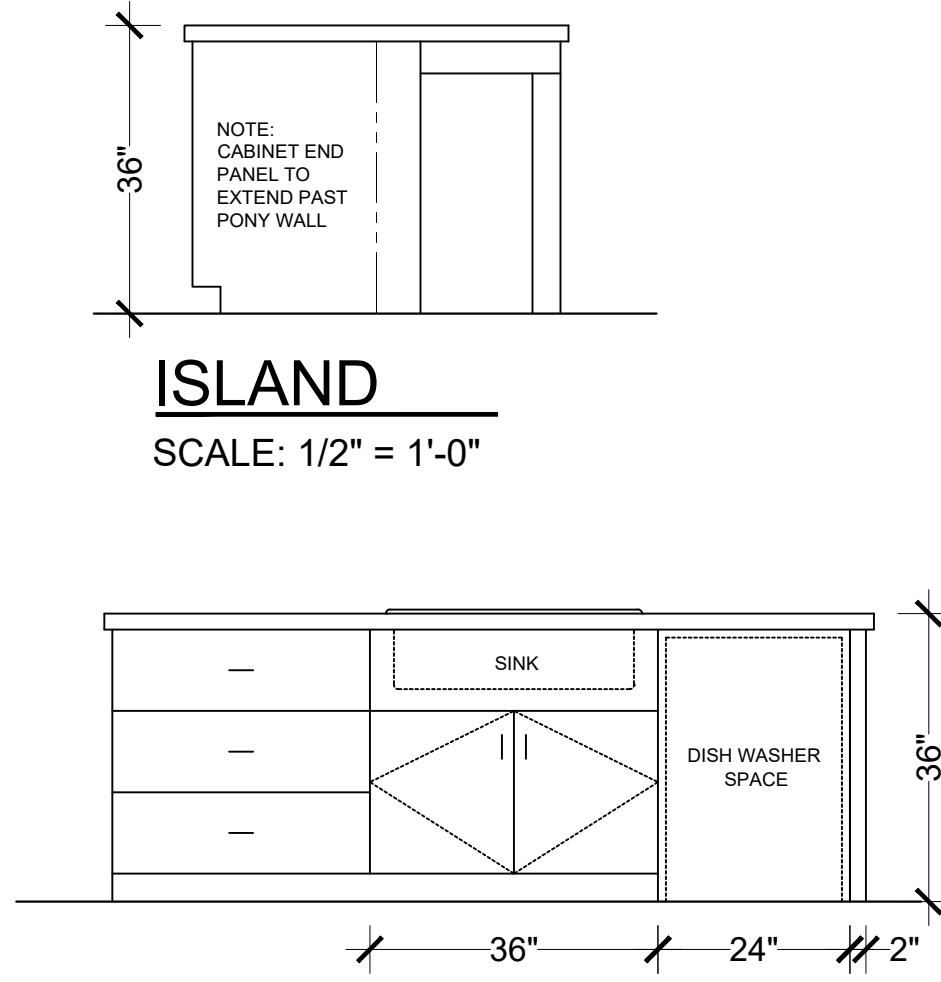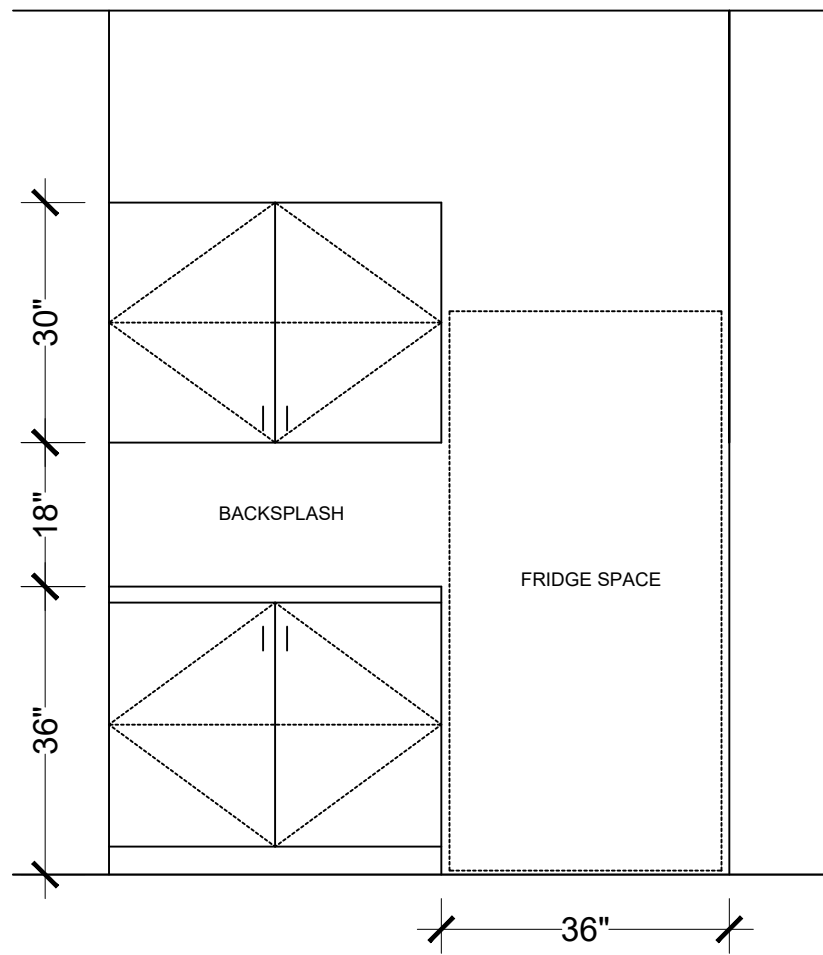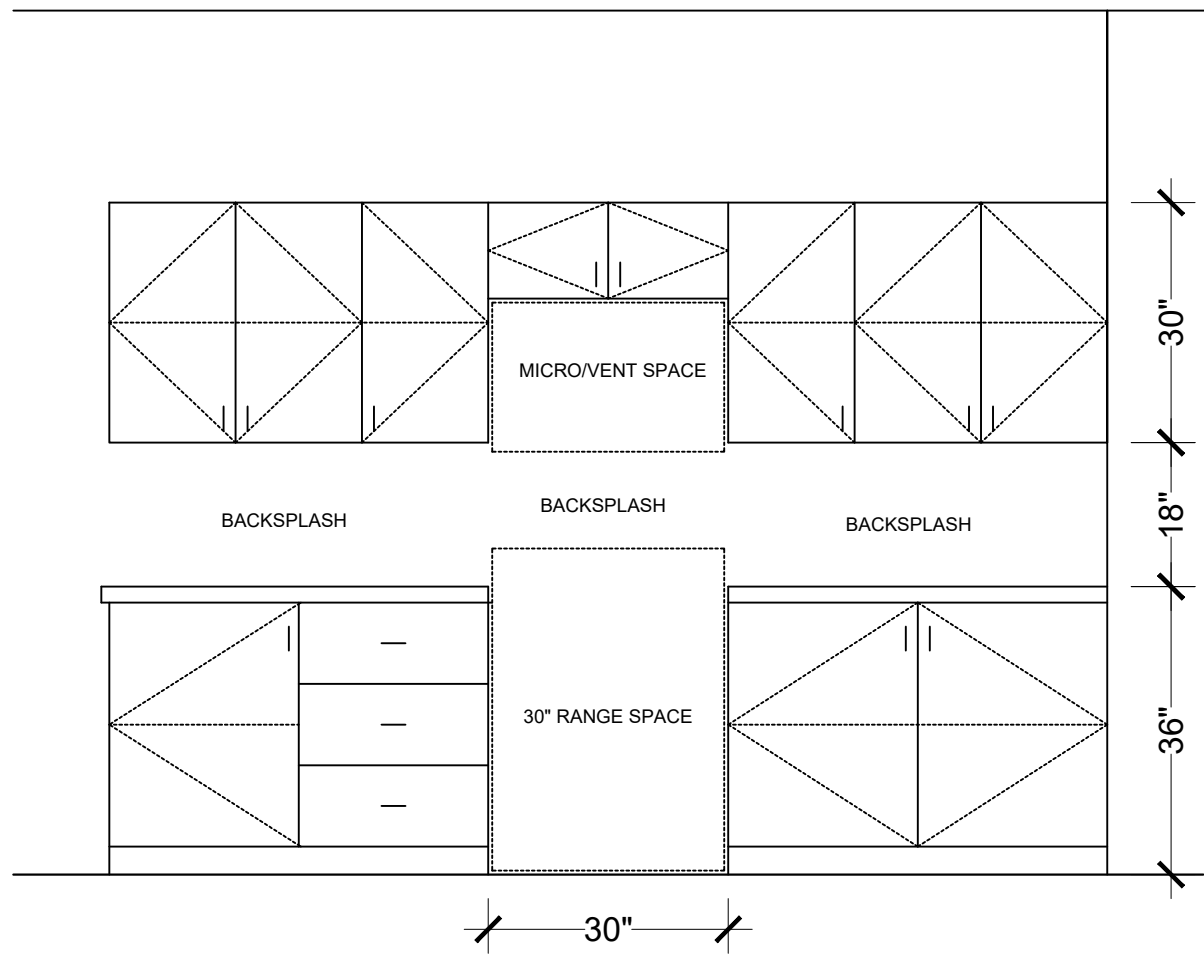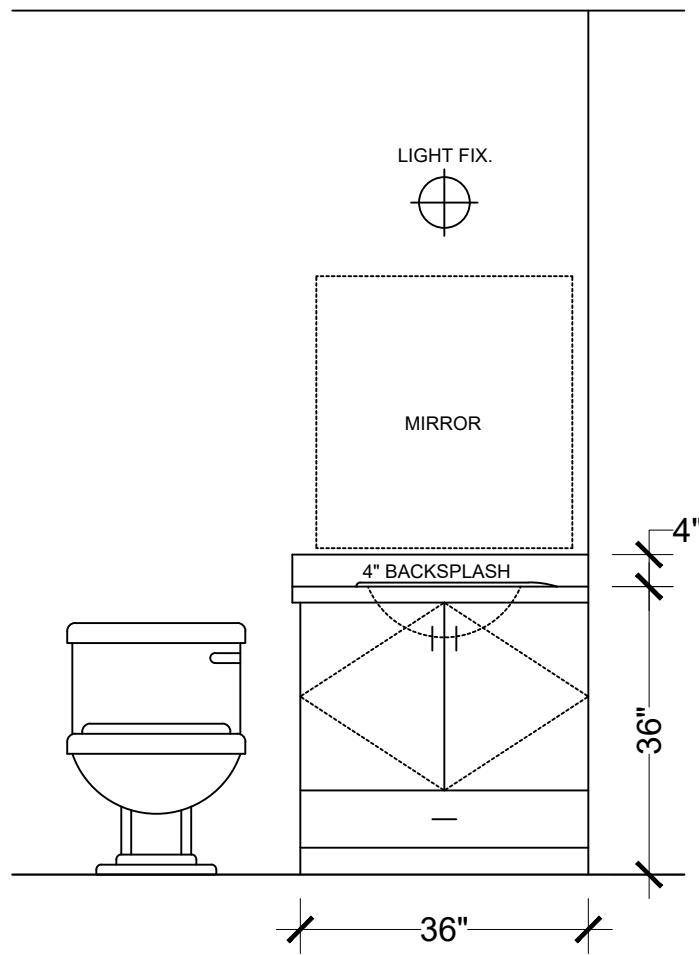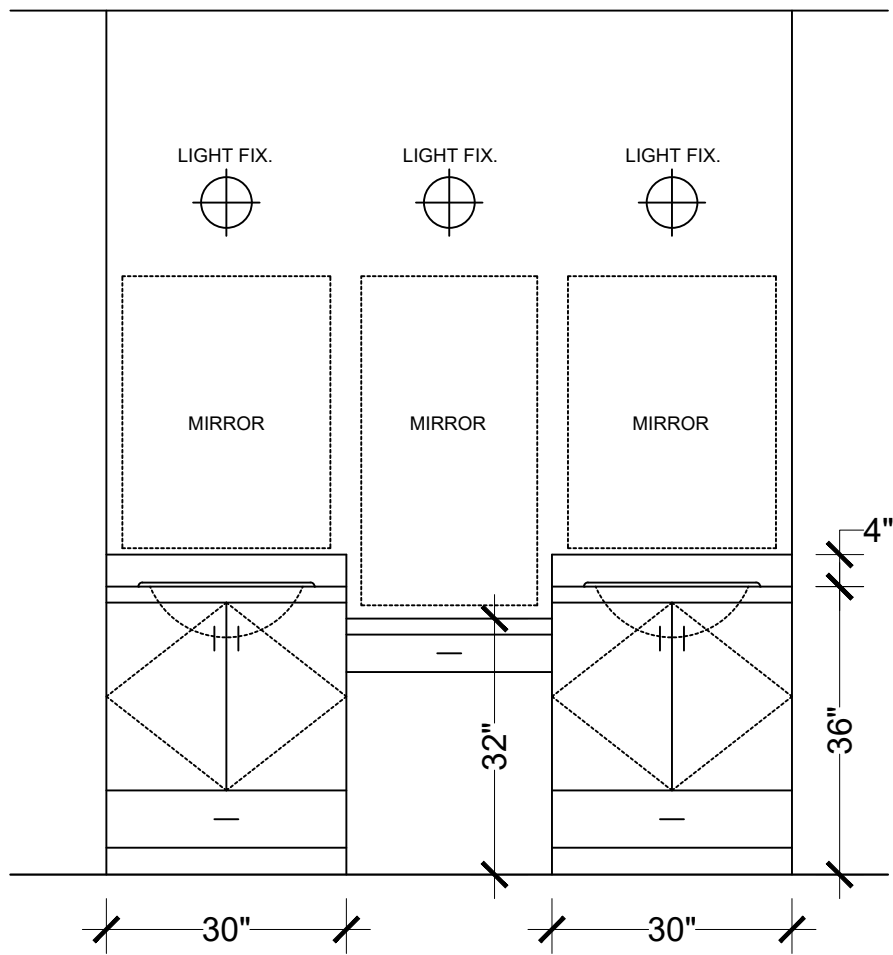

CABINET ELEVATIONS

NOTE:
CONTRACTOR TO VERIFY CABINET DIMENSIONS BEFORE FABRICATION



Heritage Crafted Homes

No.	Revision/Issue	Date

Firm Name and Address
Heritage Crafted homes
200 SE Loop 410, Ste 108
San Antonio, TX 78220

Project Name and Address
Jose Charo
1315 E. Pyron Av.
San Antonio, TX 78214

Project Charo	Sheet 6 of 6
Date 07/30/25	
Scale 1/4" = 1'-0"	