

CODE REVIEW SUMMARY

LOCATION: 370 E HUISACHE AVE. SAN ANTONIO, TEXAS 78212

OCCUPANCY CLASSIFICATION

BUILDING TYPE: SINGLE FAMILY	BUILDING AREA: 2,211 S.F.
---------------------------------	------------------------------

DRAWING INDEX

- GENERAL
- A0.01 COVER SHEET / INDEX/SURVEY
- ARCHITECTURAL
- A1.01 DEMO SITE PLAN
- A1.02 SITE PLAN
- A2.01 DEMO PLAN & FLOOR PLAN
- A3.01 ELECTRICAL PLAN & ROOF PLAN INTERIOR
- A4.01 EXTERIOR ELEVATIONS
- A5.01 CROSS SECTION & MILLWORK

Huisache Remodel

370 E Huisache Ave
San Antonio, TX 78212

DESIGN TEAM

CIRCA DESIGN

210.421.8890
GENEVIE@CIRCADESIGNSA.COM

LEGEND

A0.01

SECTION IDENTIFICATION NUMBER

9

NUMBER OF SHEET IN WHICH SECTION IS DRAWN

A

DEMOLITION KEYNOTE

12

WINDOW NUMBER

0/A0.0

0/A0.0

0/A0.0

ELEVATION IDENTIFICATION

+

461.0

EXISTING ELEVATION

+

100.00

NEW ELEVATION

FINISH FLOOR

LEVEL DESCRIPTION

6

FLOOR CHANGE AMOUNT

6

FLOOR CHANGE

CL

CENTERLINE

1

DETAIL

FULL

SCALE OF DRAWING

=====

EXISTING CONST. TO REMAIN

=====

EXISTING CONST. TO BE REMOVED

=====

NEW CONSTRUCTION

1 HR. SEPARATION

1/A&1

DETAIL NUMBER

1/A&1

SHEET NUMBER OF DETAIL

NORTH


NORTH INDICATOR

1/A&1

DETAIL NUMBER

1/A&1

SHEET NUMBER OF DETAIL

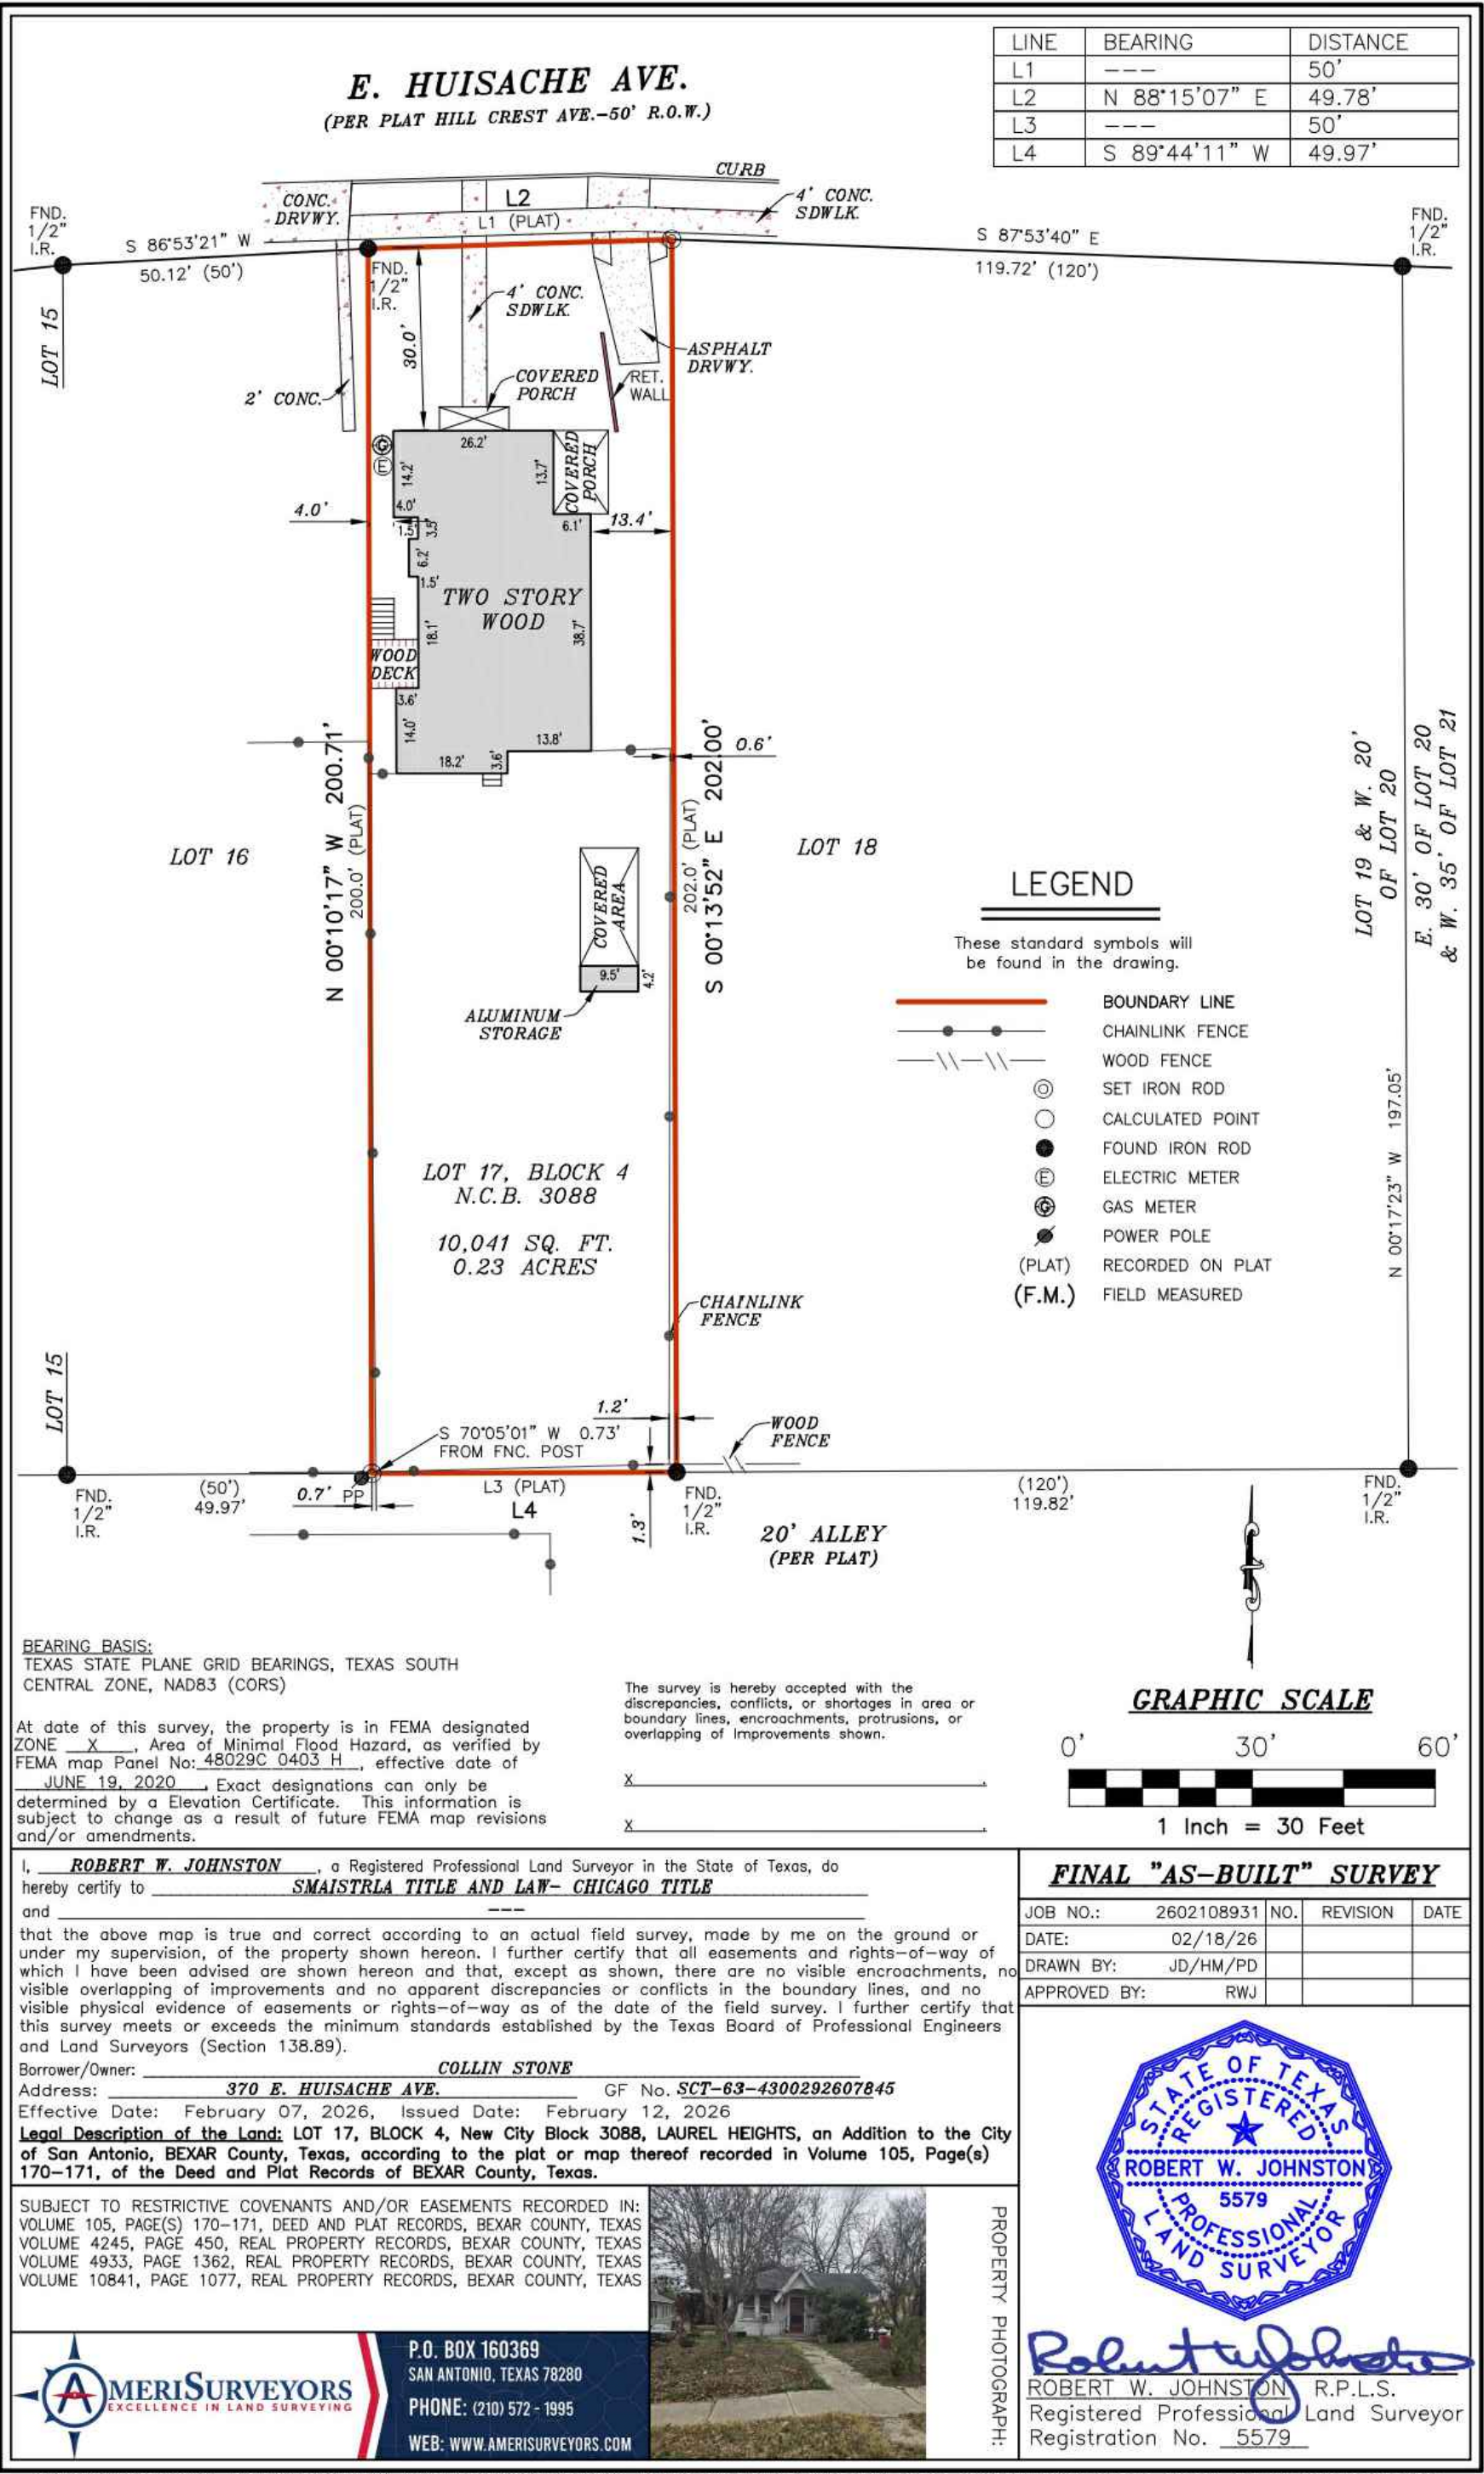

APPLICABLE BUILDING CODES & AUTHORITIES

- 2024 International Building Code
2024 International Residential Code
2024 International Existing Building Code
2024 International Mechanical Code
2024 International Plumbing Code
2024 International Fuel Gas Code
2024 International Fire Code
2024 International Energy Conservation Code
2023 National Electric Code

Local amendments to the above-listed codes may be viewed on the Development Services Department website: www.sanantonio.gov/dsd

LOCATION MAP - CITY



BUILDING OFFICIAL STAMP



DATE
EXP. DATE
CIRCA DESIGN
VOICE: (210) 421-8890
GENEVIE@CIRCADESIGNSA.COM

Huisache Remodel
370 E. Huisache Ave.
San Antonio, TX 78212

OWNER
Collin Stone
Brian Treusdell
Raul Resendiz
370 E Huisache Ave
San Antonio, TX 78212

PROJECT NUMBER
26-Huisache Ave
CONSTRUCTION DOCS
ISSUED FOR PERMIT

NO. DATE DESCRIPTION OF ISSUE


THIS PLAN AND THE DESIGNS CONTAINED HEREIN ARE THE PROPERTY OF CIRCA DESIGN AND MAY NOT BE REPRODUCED, ALL OR IN PART, WITHOUT WRITTEN CONSENT FROM CIRCA DESIGN.
CIRCA DESIGN IS A DESIGN COMPANY, NOT AN ENGINEERING FIRM. WE DO NOT QUALIFY TO BE ONE NOR ARE WE LICENSED TO DESIGN STRUCTURAL FRAMING, WINDBRACING OR FOUNDATIONS. A LICENSED PROFESSIONAL ENGINEER SHOULD BE CONTRACTED AND CONSULTED IMMEDIATELY REGARDING FRAMING, WINDBRACING AND THE FOUNDATION DESIGNS. SHOULD AN ENGINEER'S SEAL BE PRESENT ON THESE DRAWINGS, THE ENGINEER OF RECORD SHALL BEAR ALL RESPONSIBILITY FOR THE STRUCTURE, WINDBRACING AND FOUNDATION DESIGNS FOR THIS PROJECT. CIRCA DESIGN IS NOT TO BE HELD RESPONSIBLE FOR THE STRUCTURAL DESIGN IN ANY WAY MATTER OR FORM IF ANY ISSUES OR PROBLEMS ARISE.

SHEET TITLE
Cover Sheet / /index

DATE
4 May 2026
SHEET NUMBER

BAR LENGTH ON ORIGINAL DRAWING EQUALS 1 INCH

A0.01

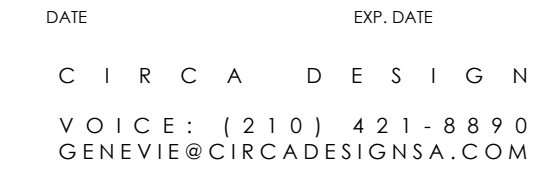

370 E. Hulsache Ave.
San Antonio, TX 78212

PROJECT NUMBER
6-Huisache Ave


NO.	DATE	DESCRIPTION OF ISSUE
-----	------	----------------------


CA DESIGN IS A DESIGN COMPANY, NOT AN ENGINEERING FIRM. WE DO NOT QUALIFY TO BE ONE NOR ARE WE LICENSED TO DO STRUCTURAL FRAMING, BRACING OR FOUNDATION DESIGN. ANY PROFESSIONAL ENGINEER SHOULD BE CONTACTED TO CONSULT IMMEDIATELY REGARDING FRAMING, BRACING AND THE FOUNDATION DESIGNS. SHOULD AN ENGINEER'S SEAL BE PRESENT ON THESE DRAWINGS, THE "ENGINEER RECORD" SHALL BEAR ALL RESPONSIBILITY FOR THE STRUCTURE, BRACING AND FOUNDATION DESIGNS FOR THIS PROJECT. CA DESIGN IS NOT TO BE HELD RESPONSIBLE FOR THE STRUCTURAL DESIGN IN ANY WAY MATTER OR FORM IF ANY ISSUES OR PROBLEMS ARISE.

Demo Site Plan

R LENGTH ON
 GINAL DRAWING
 UALS 1 INCH

A1.01

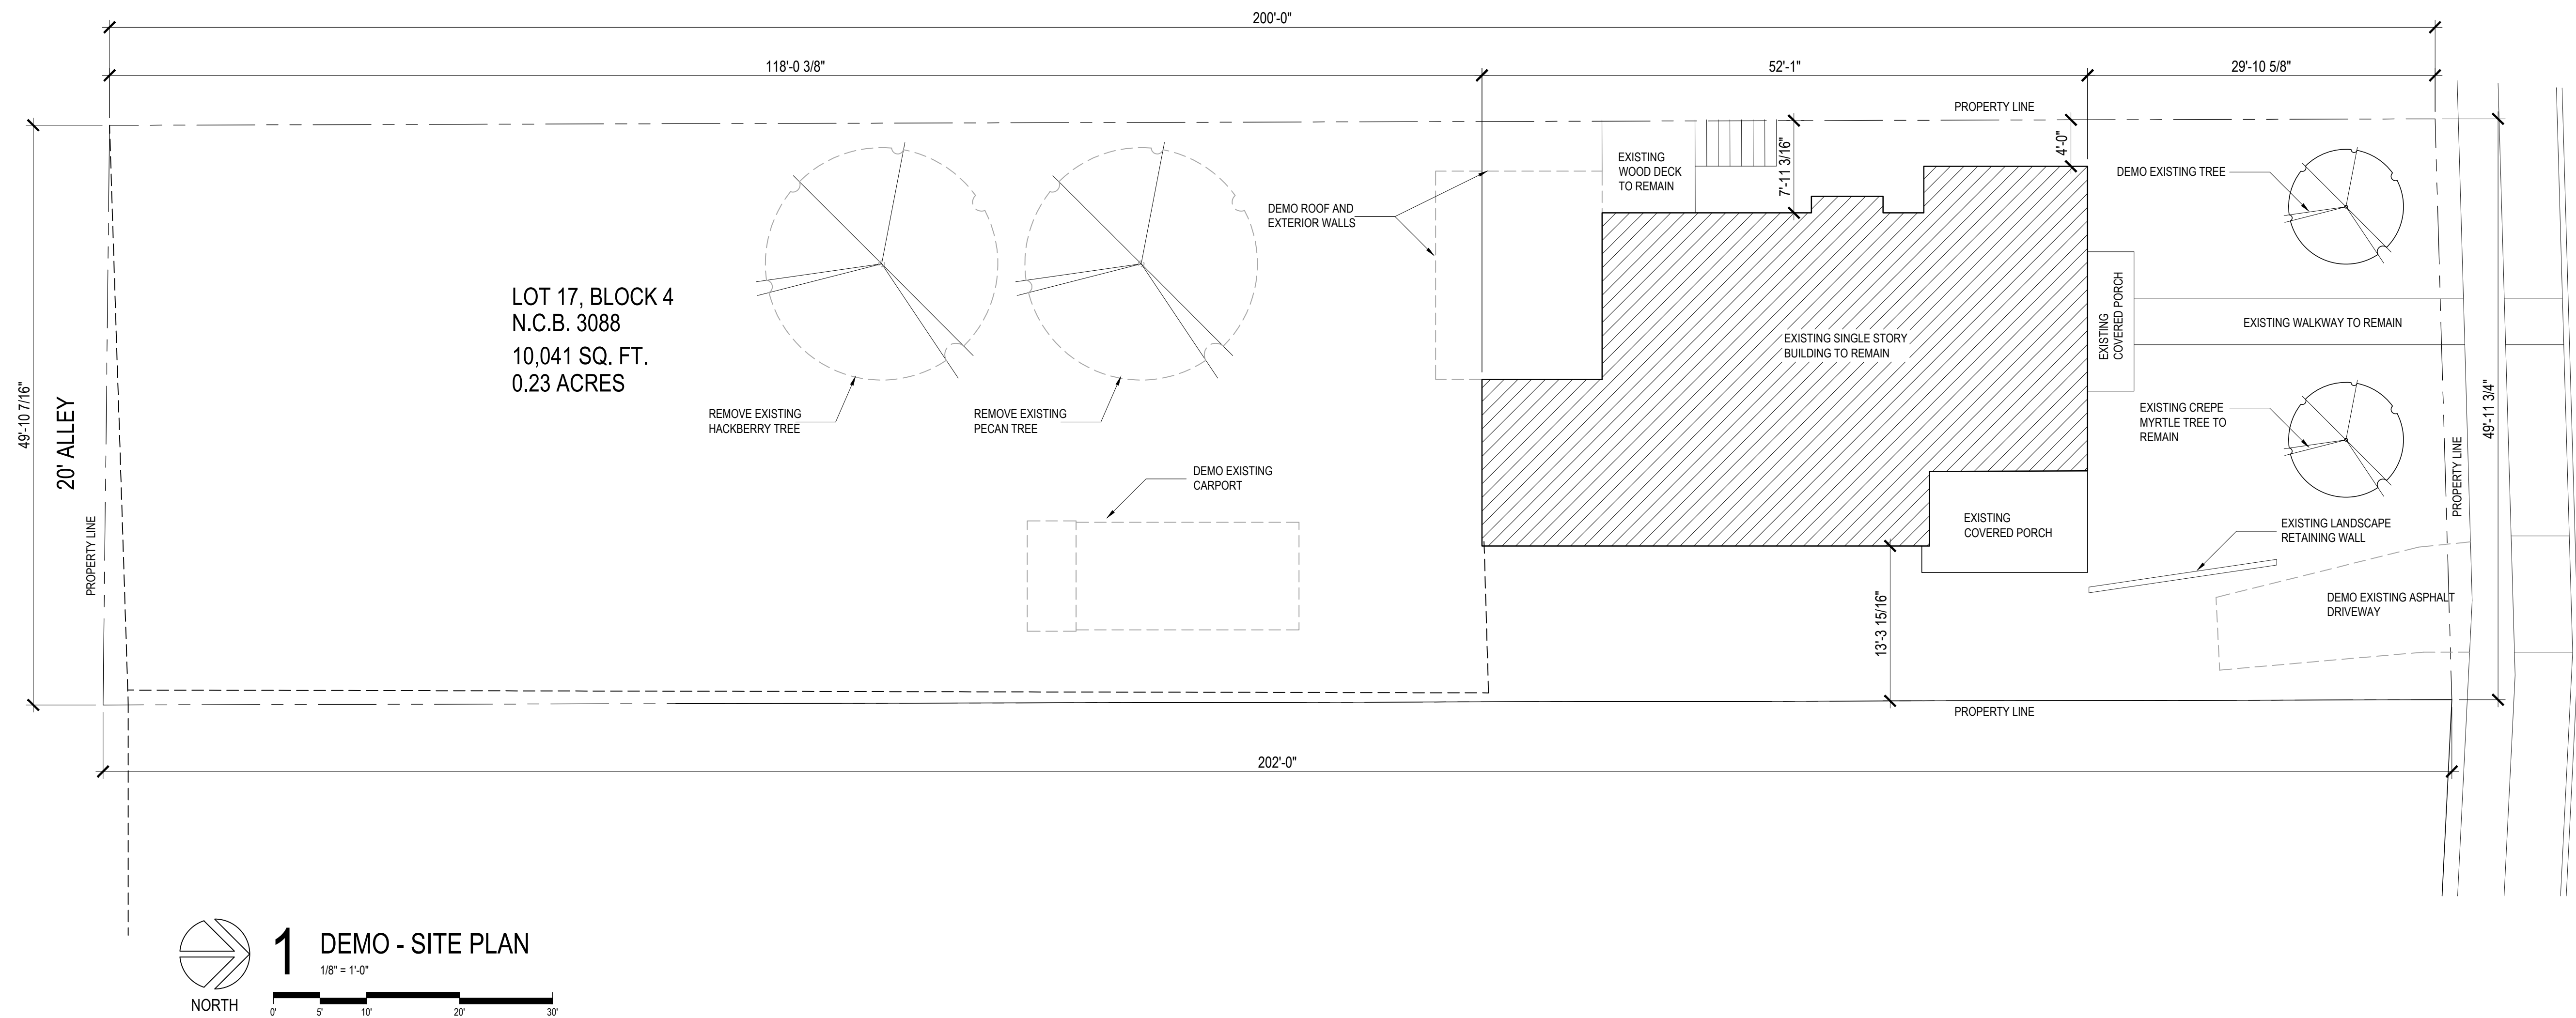

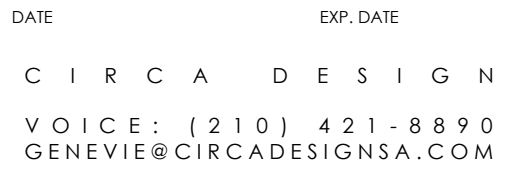

370 E. Hulsache Ave.
San Antonio, TX 78212

PROJECT NUMBER
26-Huisache Ave


NO.	DATE	DESCRIPTION OF ISSUE
-----	------	----------------------

Site Plan






R LENGTH ON
 GINAL DRAWING
 UALS 1 INCH


SHEET NUMBER

A1.02

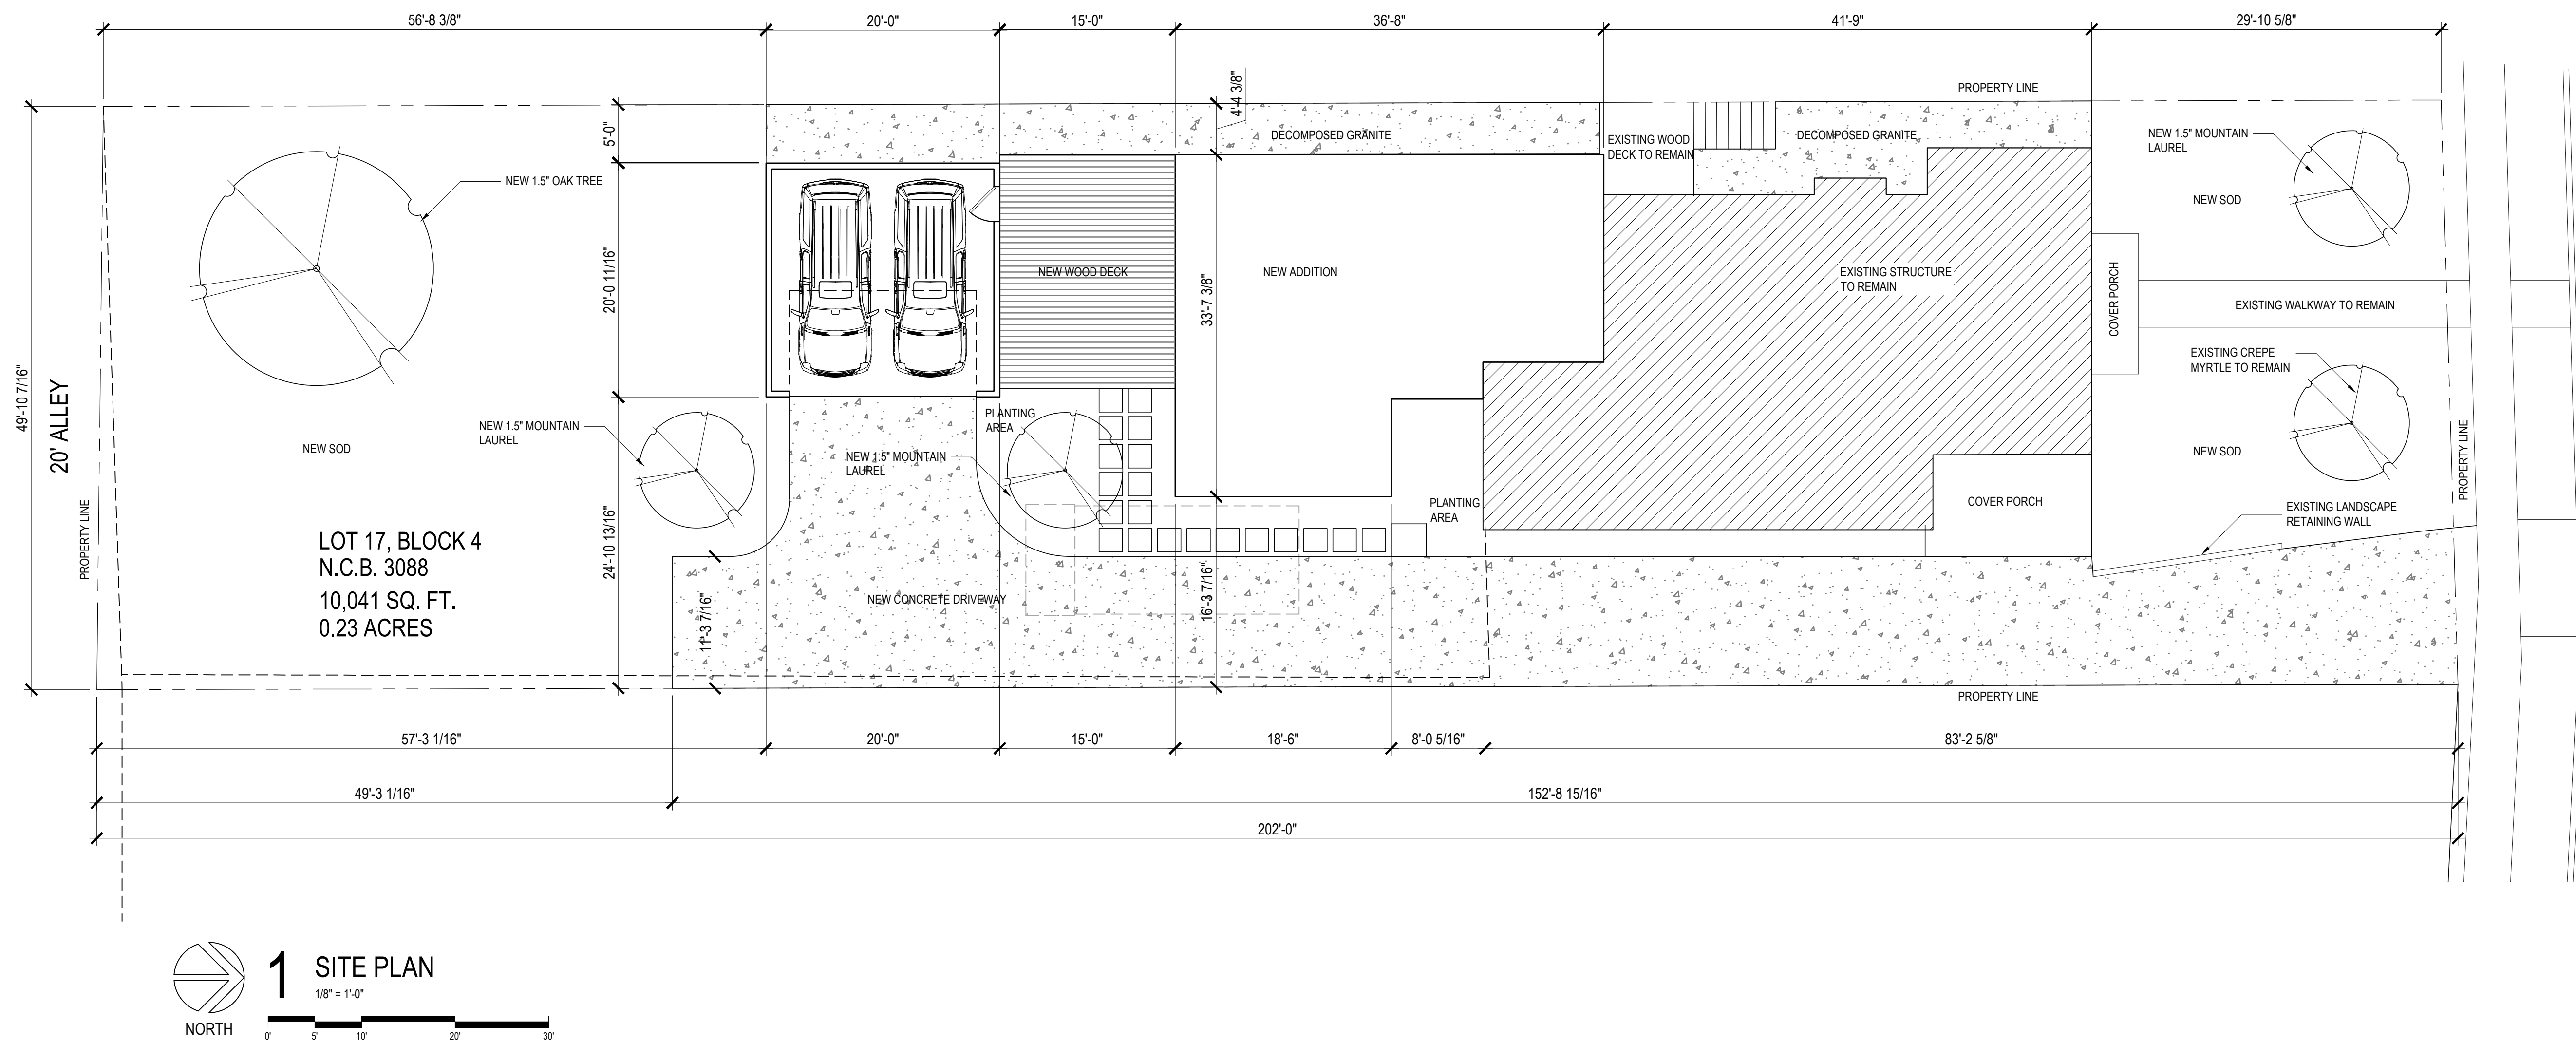


A2.01

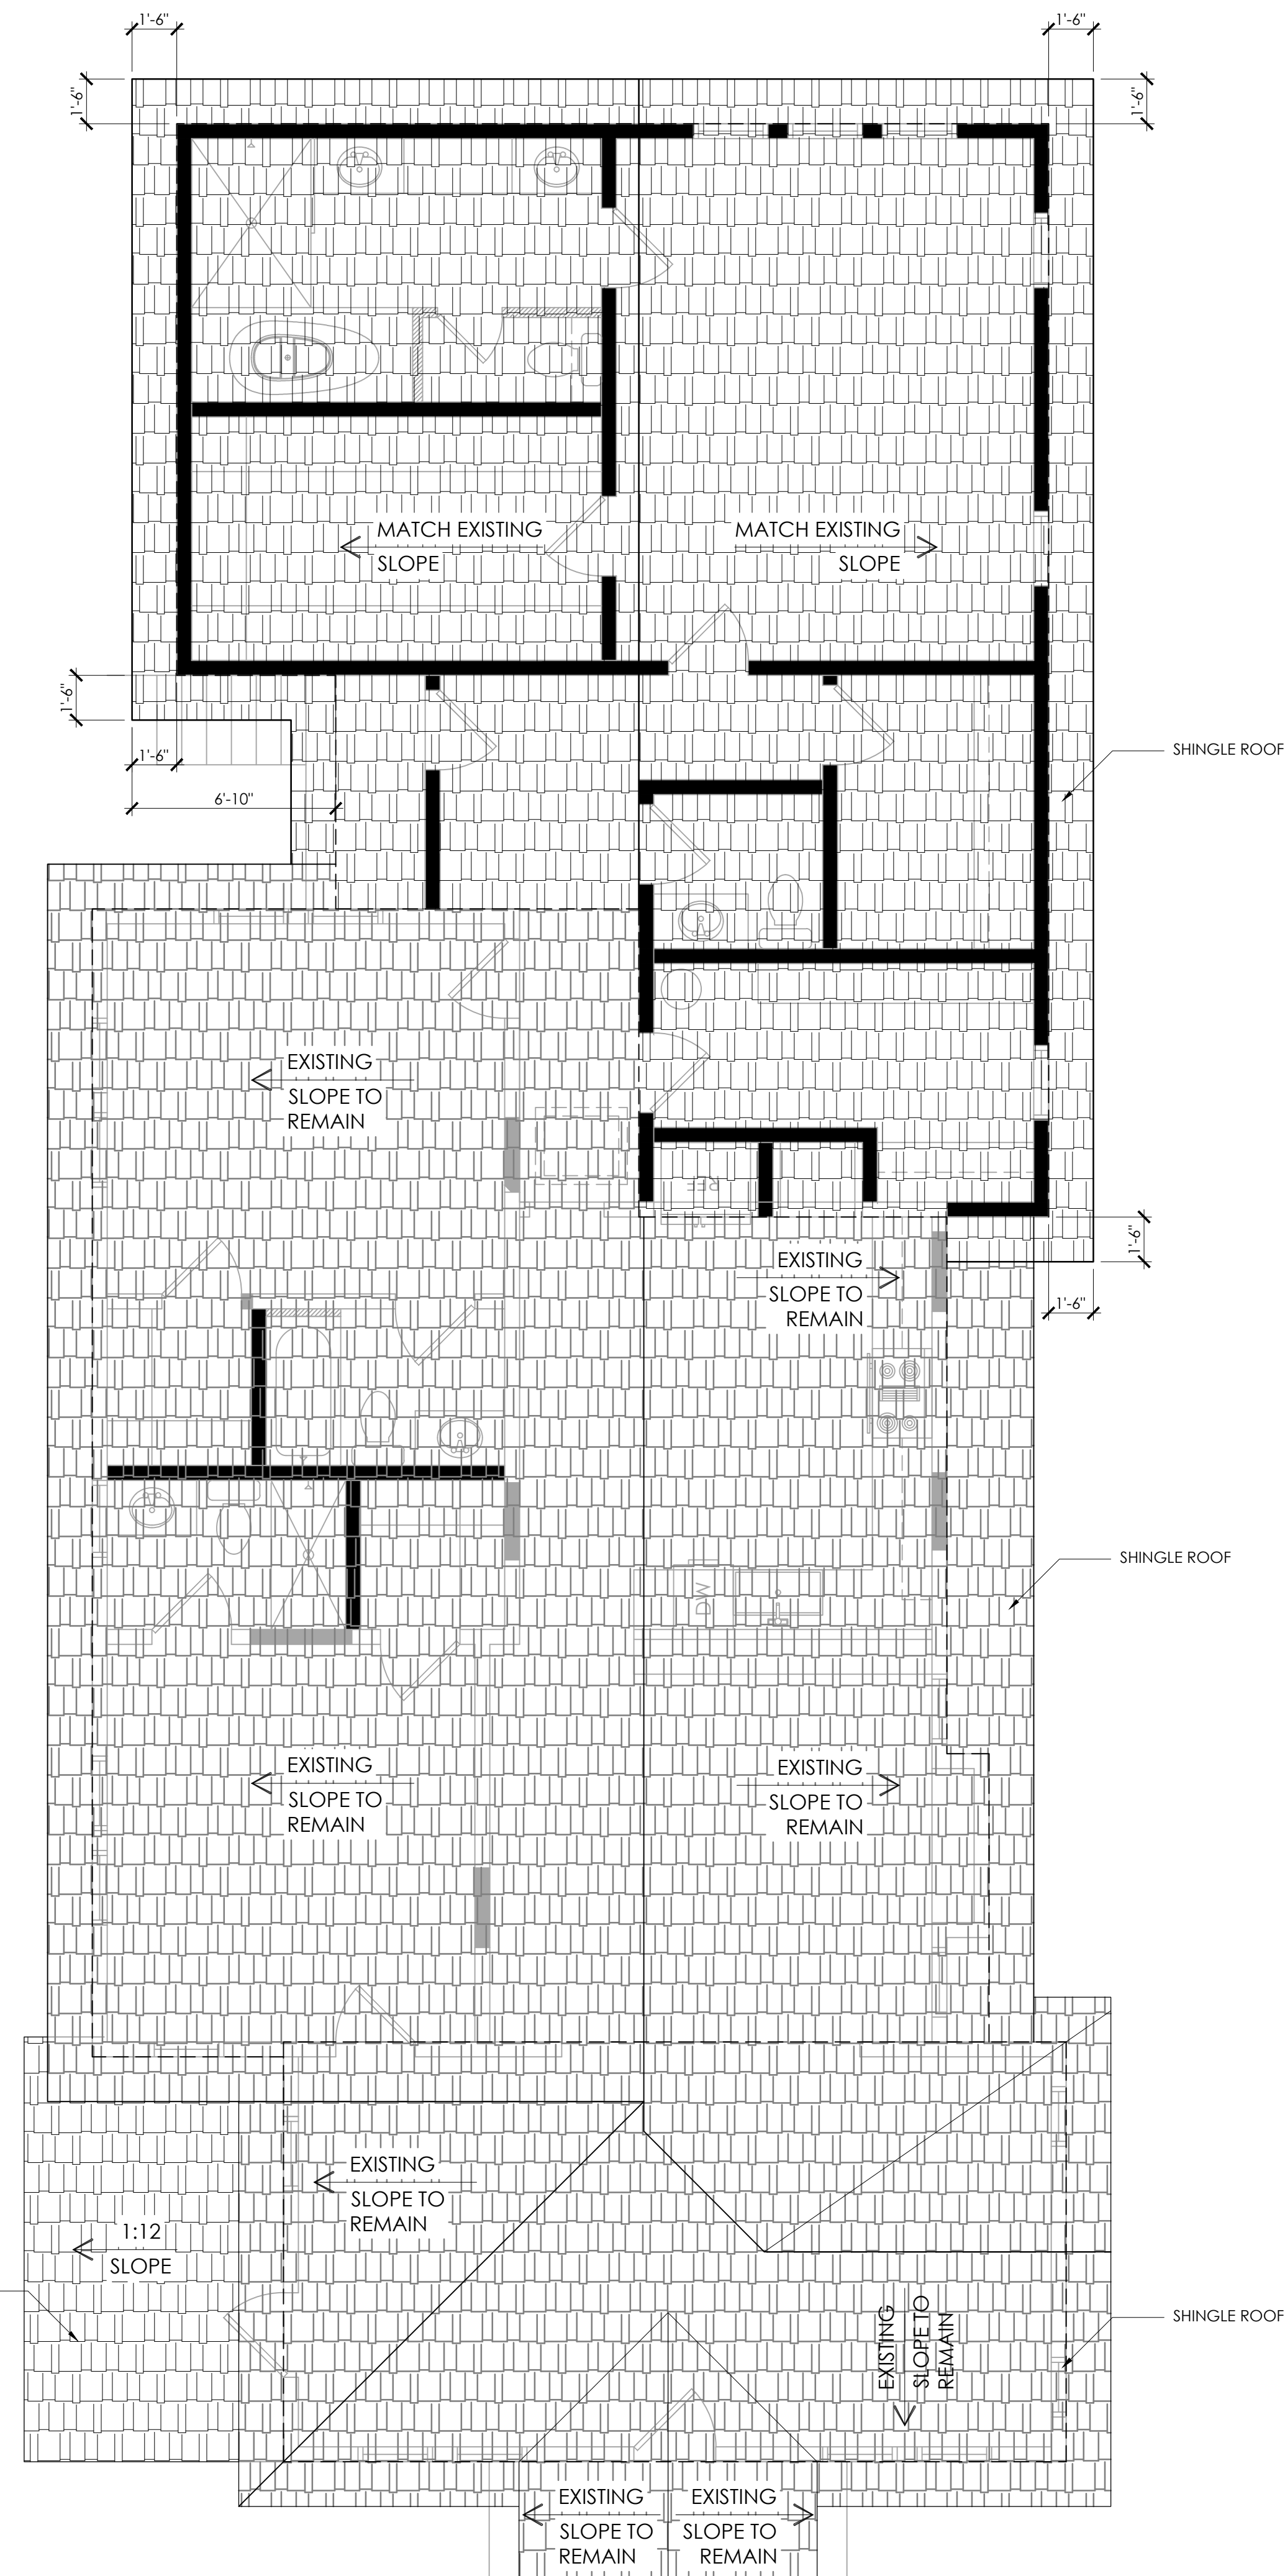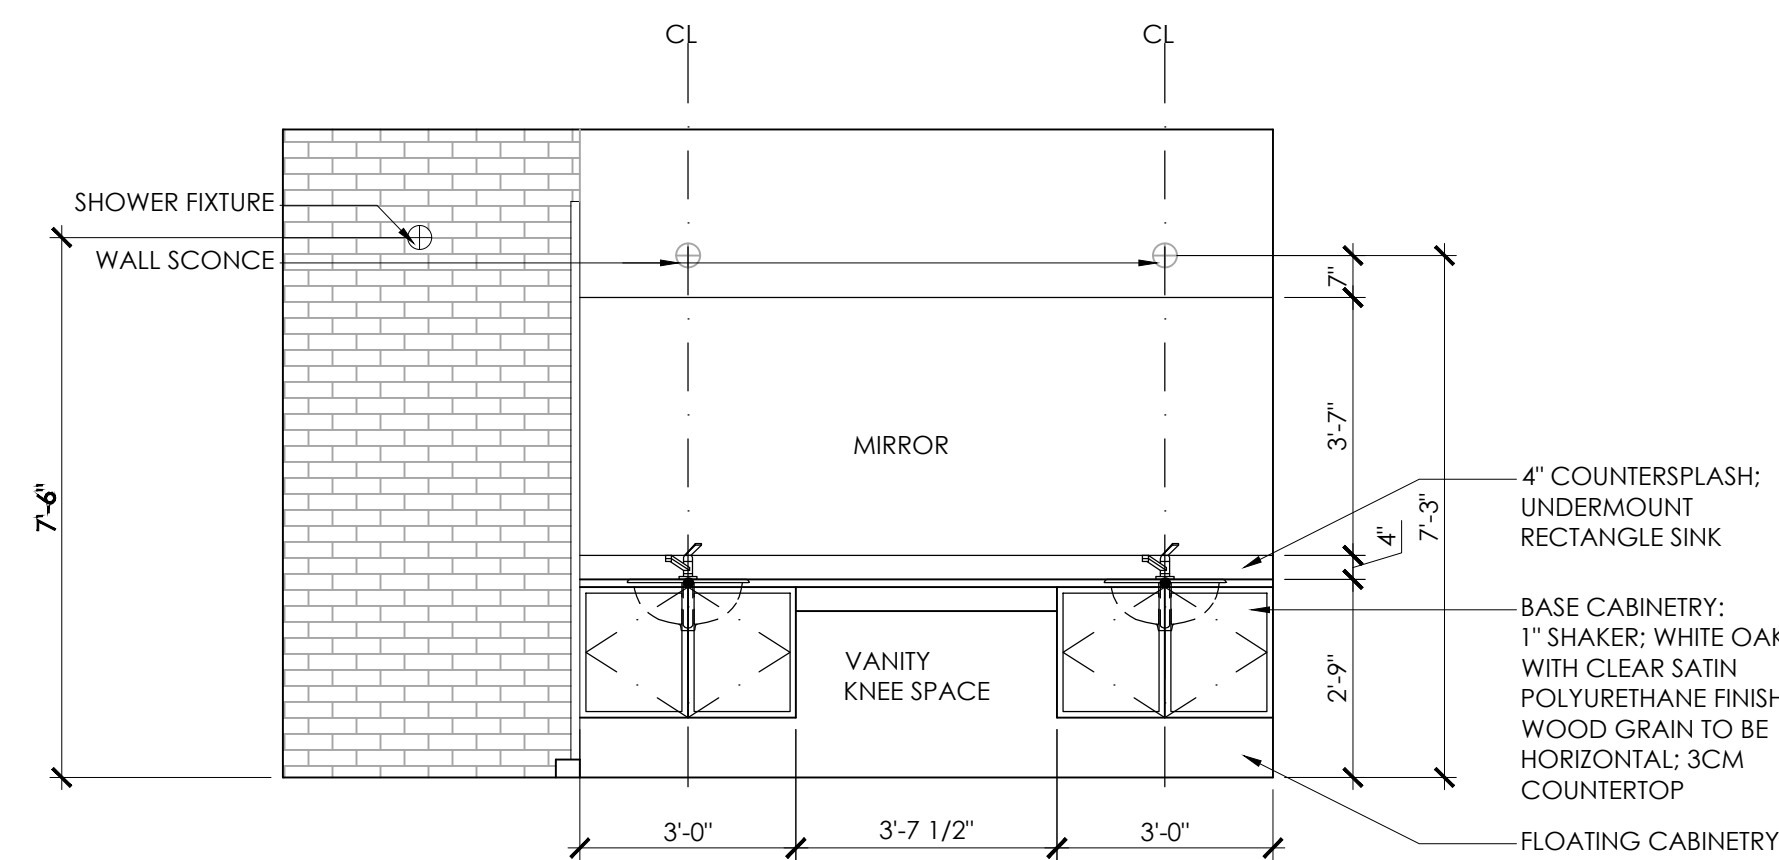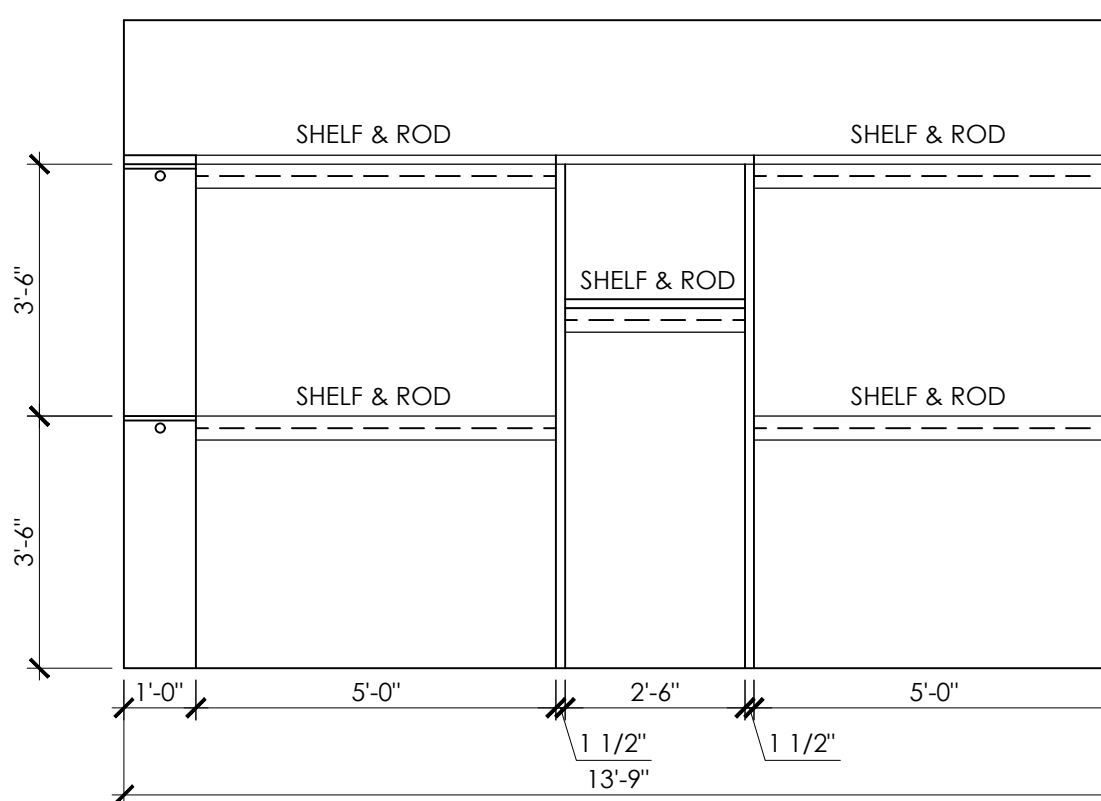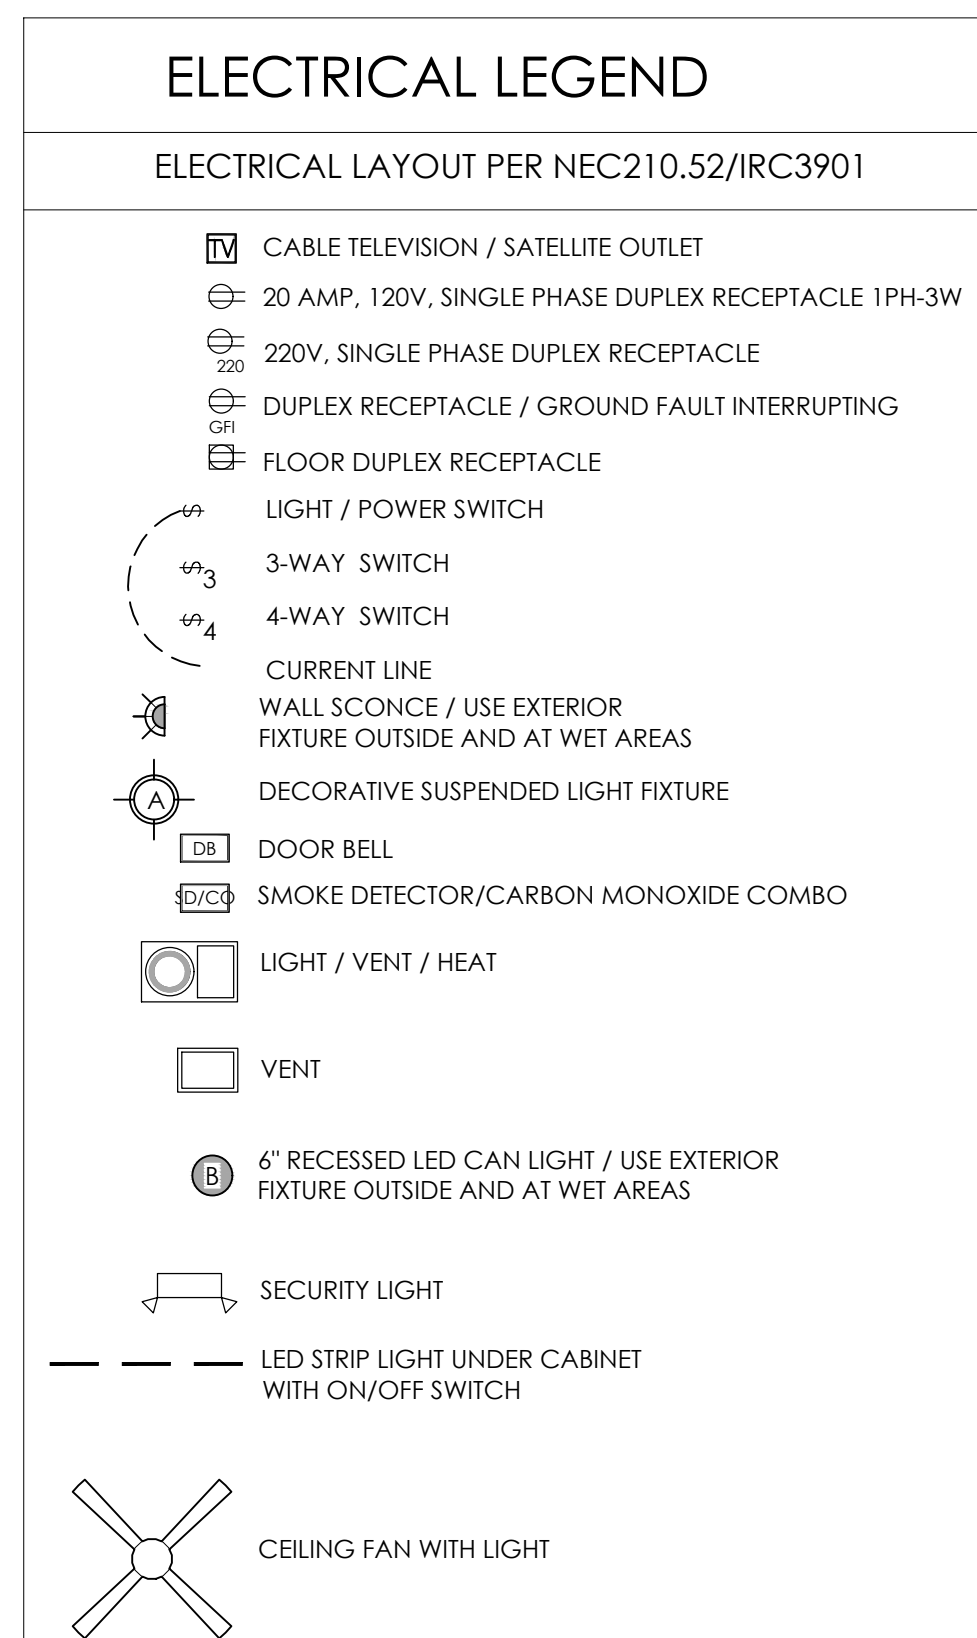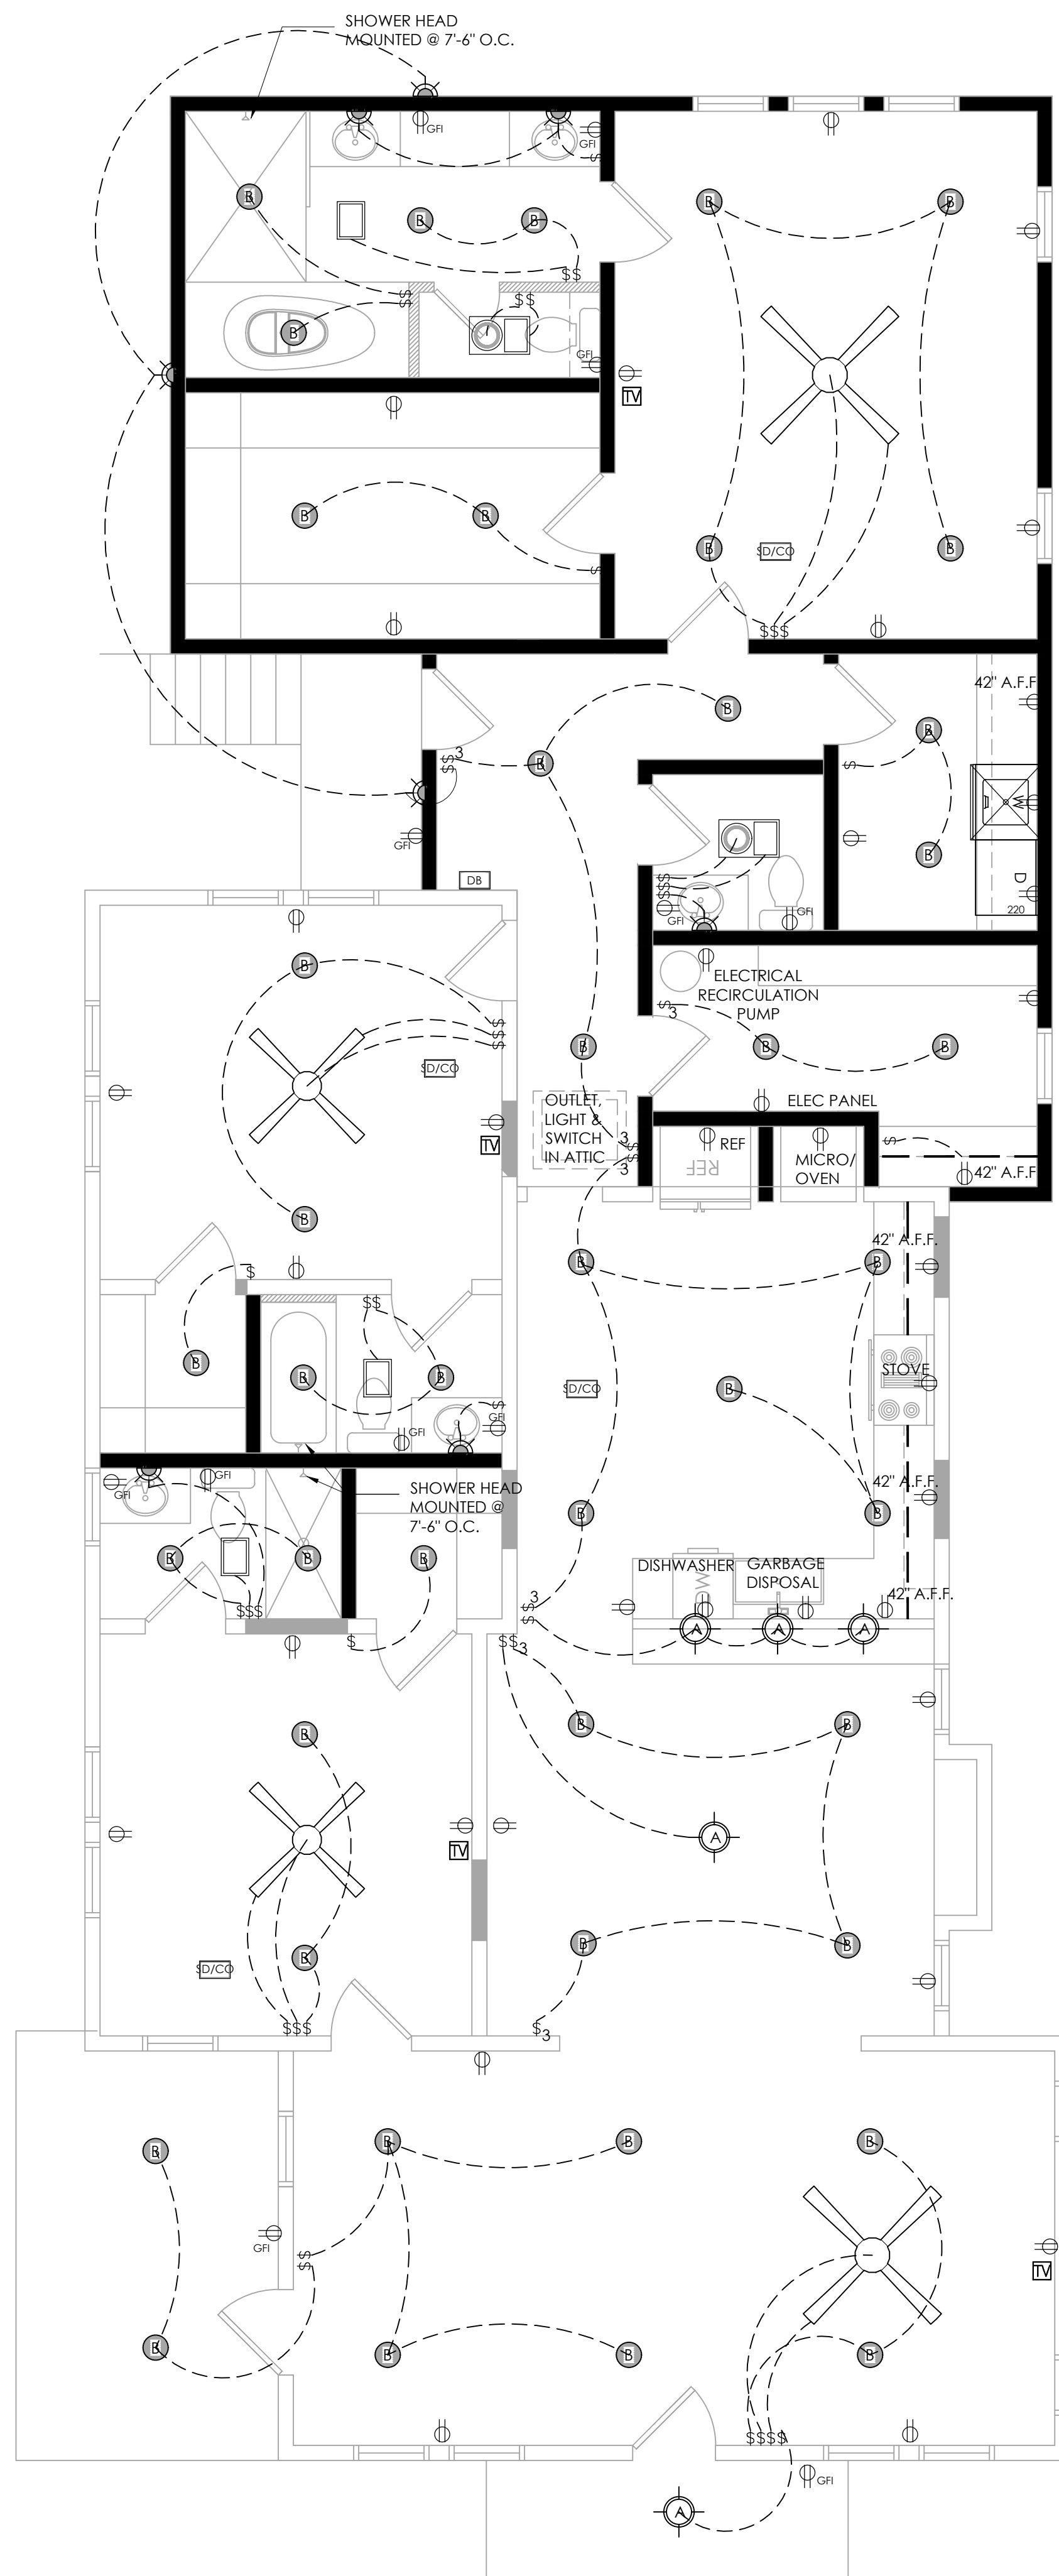


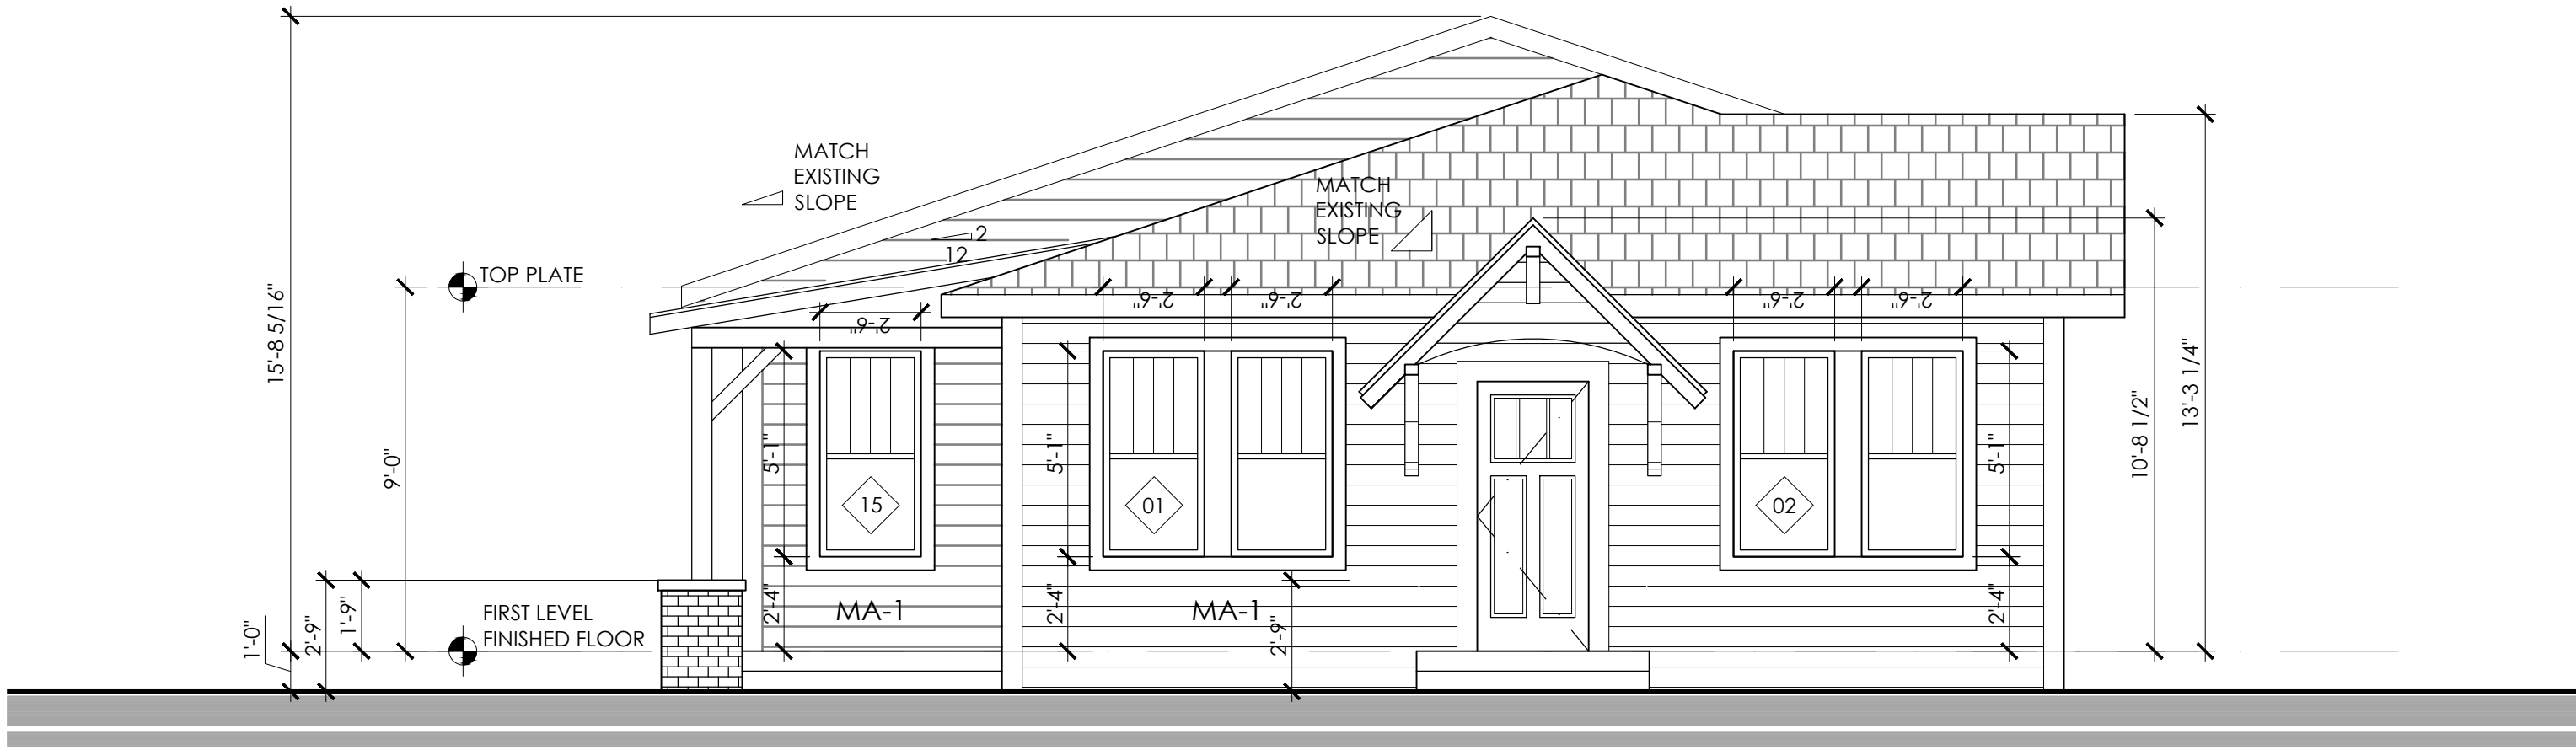


N EXTERIOR ELEVATION
1/4" = 1'-0"

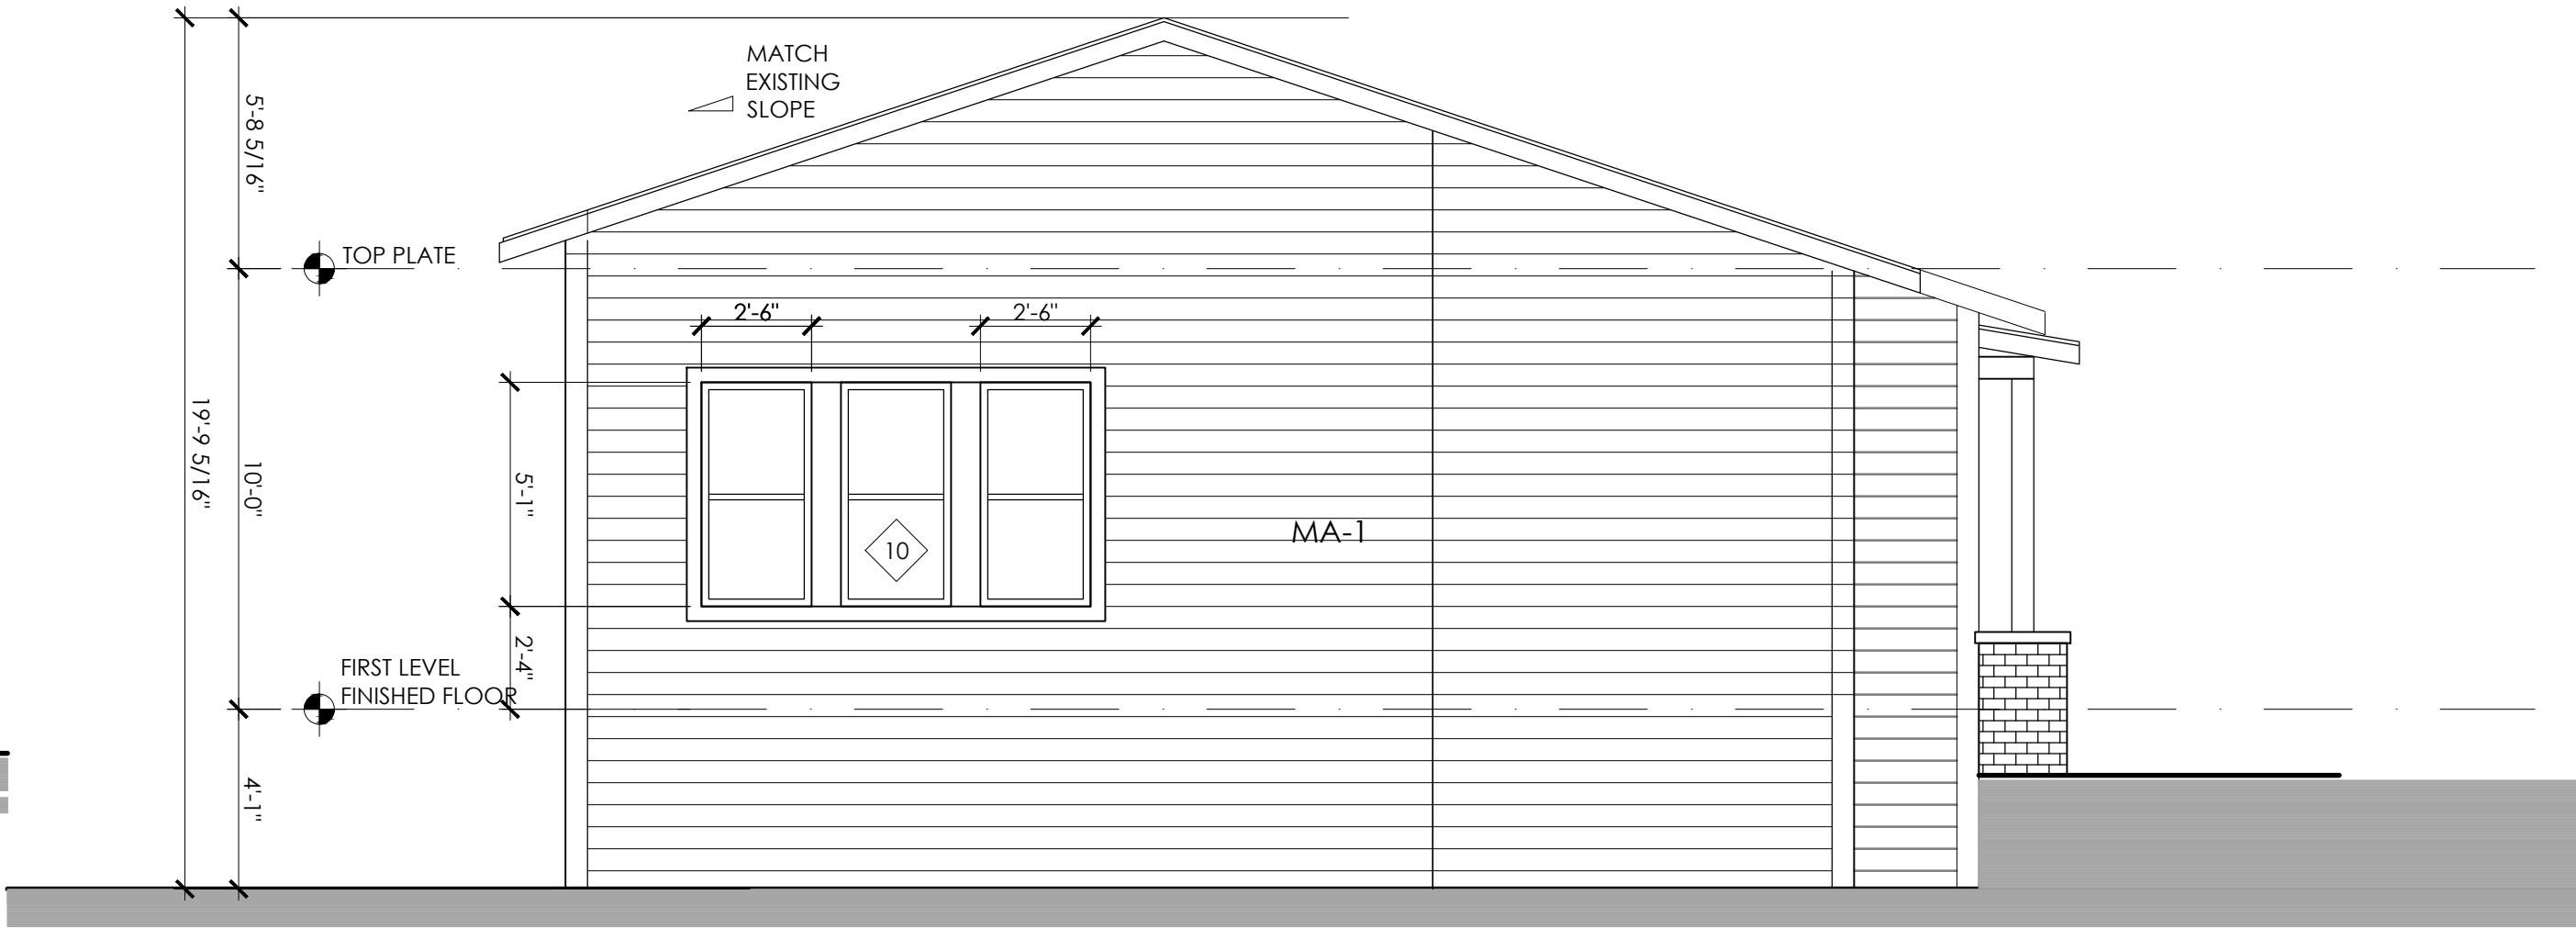

S EXTERIOR ELEVATION
1/4" = 1'-0"

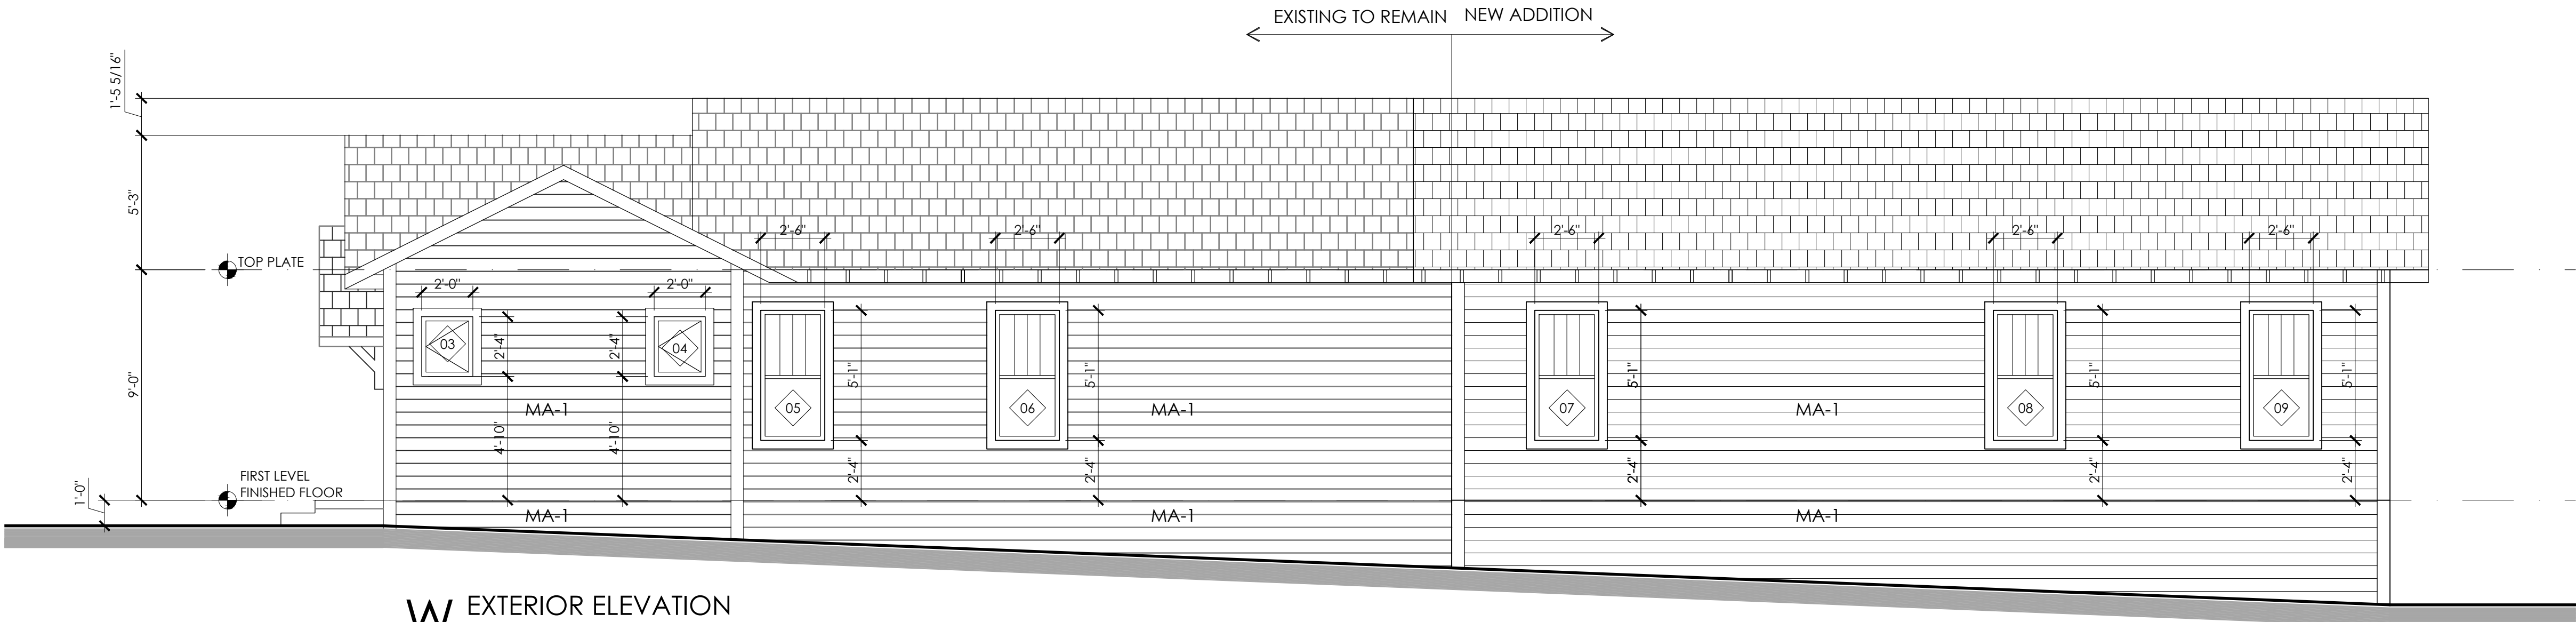

W EXTERIOR ELEVATION
1/4" = 1'-0"

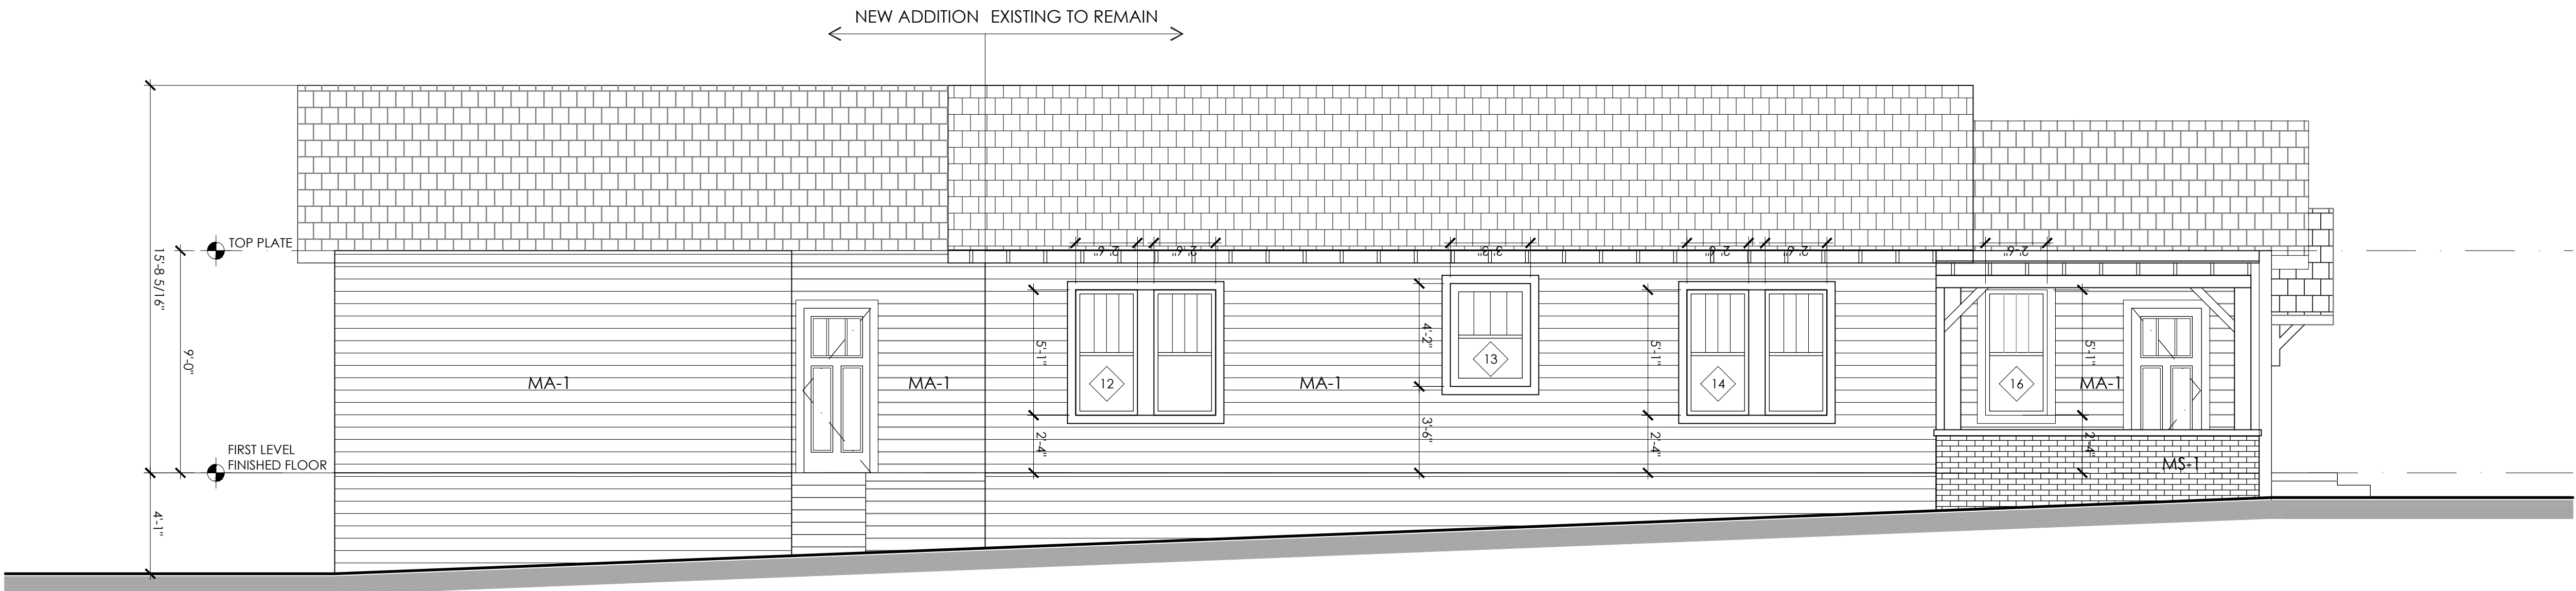

E EXTERIOR ELEVATION
1/4" = 1'-0"

LEGEND
MA-1: PATTER 117 SIDING
MS-1: MASONRY

CIRCA

DESIGN

DATE: EXP. DATE:

CIRCA DESIGN

VOICE: (210) 421-8890

GENEVIE@CIRCADESIGNSA.COM

Huisache Remodel

370 E. Huisache Ave.
San Antonio, TX 78212

OWNER: Collin Stone
Brian Treusdell
Raul Resendiz
370 E Huisache Ave
San Antonio, TX 78212

PROJECT NUMBER: 26-Huisache Ave

CONSTRUCTION DOCS
ISSUED FOR PERMIT

NO. DATE DESCRIPTION OF ISSUE












THIS PLAN AND THE DESIGNS CONTAINED HEREIN ARE THE PROPERTY OF CIRCA DESIGN AND MAY NOT BE REPRODUCED, ALL OR IN PART, WITHOUT WRITTEN CONSENT FROM CIRCA DESIGN.

CIRCA DESIGN IS A DESIGN COMPANY, NOT AN ENGINEERING FIRM. WE DO NOT QUALIFY TO BE ONE NOR ARE WE LICENSED TO DESIGN STRUCTURAL FRAMING, WINDBRACING OR FOUNDATIONS. A LICENSED PROFESSIONAL ENGINEER SHOULD BE CONTRACTED AND CONSULTED IMMEDIATELY REGARDING FRAMING, WINDBRACING AND THE FOUNDATION DESIGNS. SHOULD AN ENGINEER'S SEAL BE PRESENT ON THESE DRAWINGS, THE ENGINEER OF RECORD SHALL BEAR ALL RESPONSIBILITY FOR THE STRUCTURE, WINDBRACING AND FOUNDATION DESIGNS FOR THIS PROJECT. CIRCA DESIGN IS NOT TO BE HELD RESPONSIBLE FOR THE STRUCTURAL DESIGN IN ANY WAY MATTER OR FORM IF ANY ISSUES OR PROBLEMS ARISE.

SHEET TITLE: Exterior Elevations

DATE: 4 May 2026 BAR LENGTH ON ORIGINAL DRAWING EQUALS 1 INCH

SHEET NUMBER: A4.01

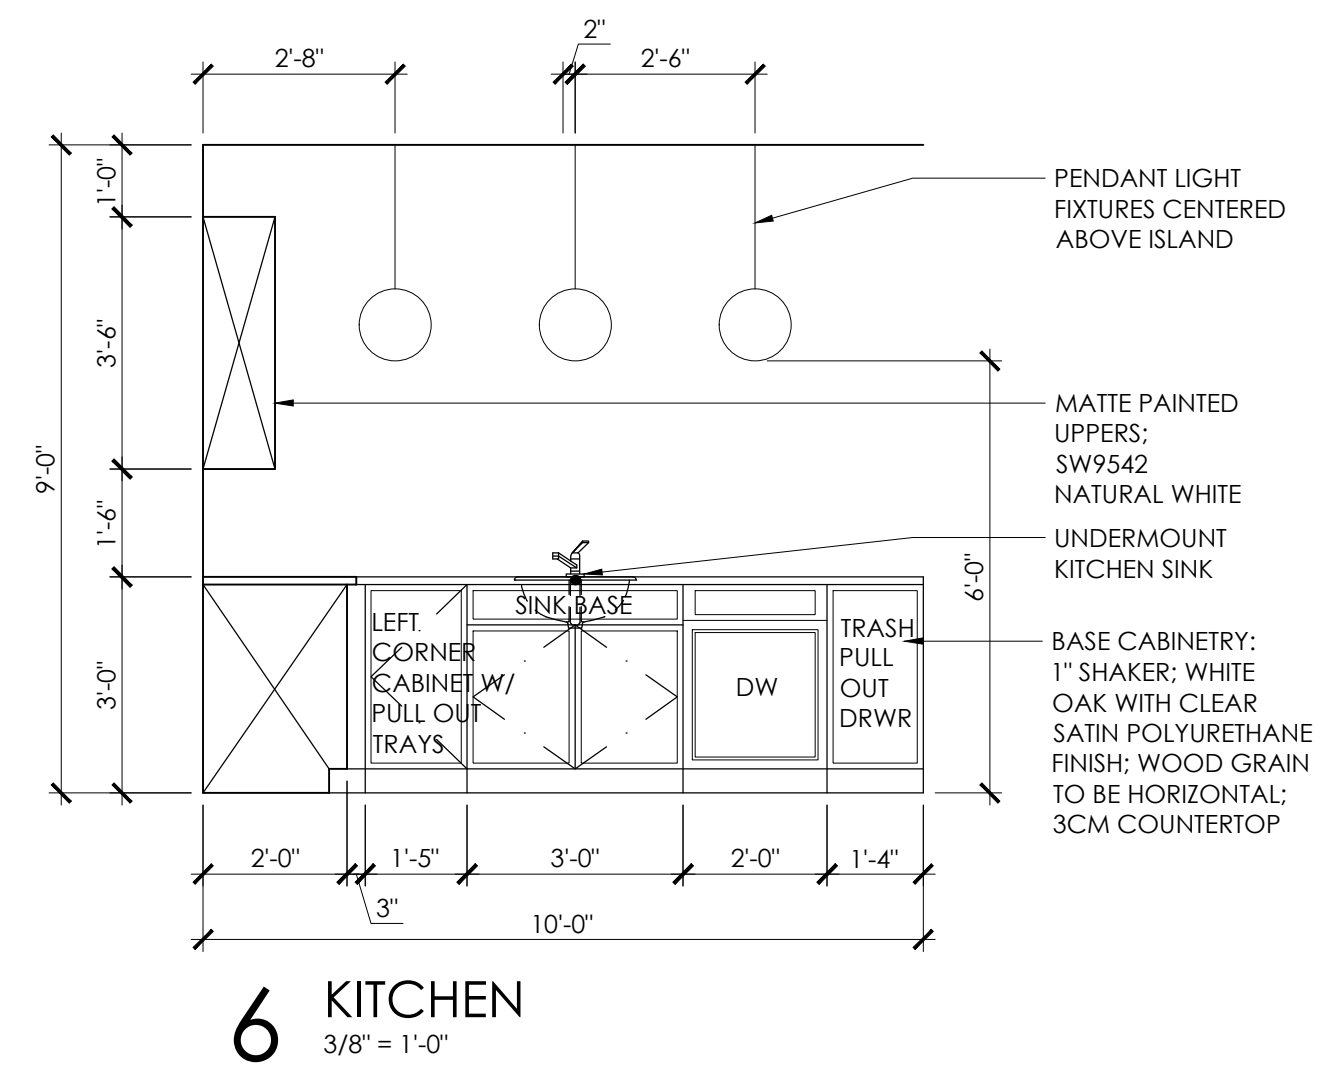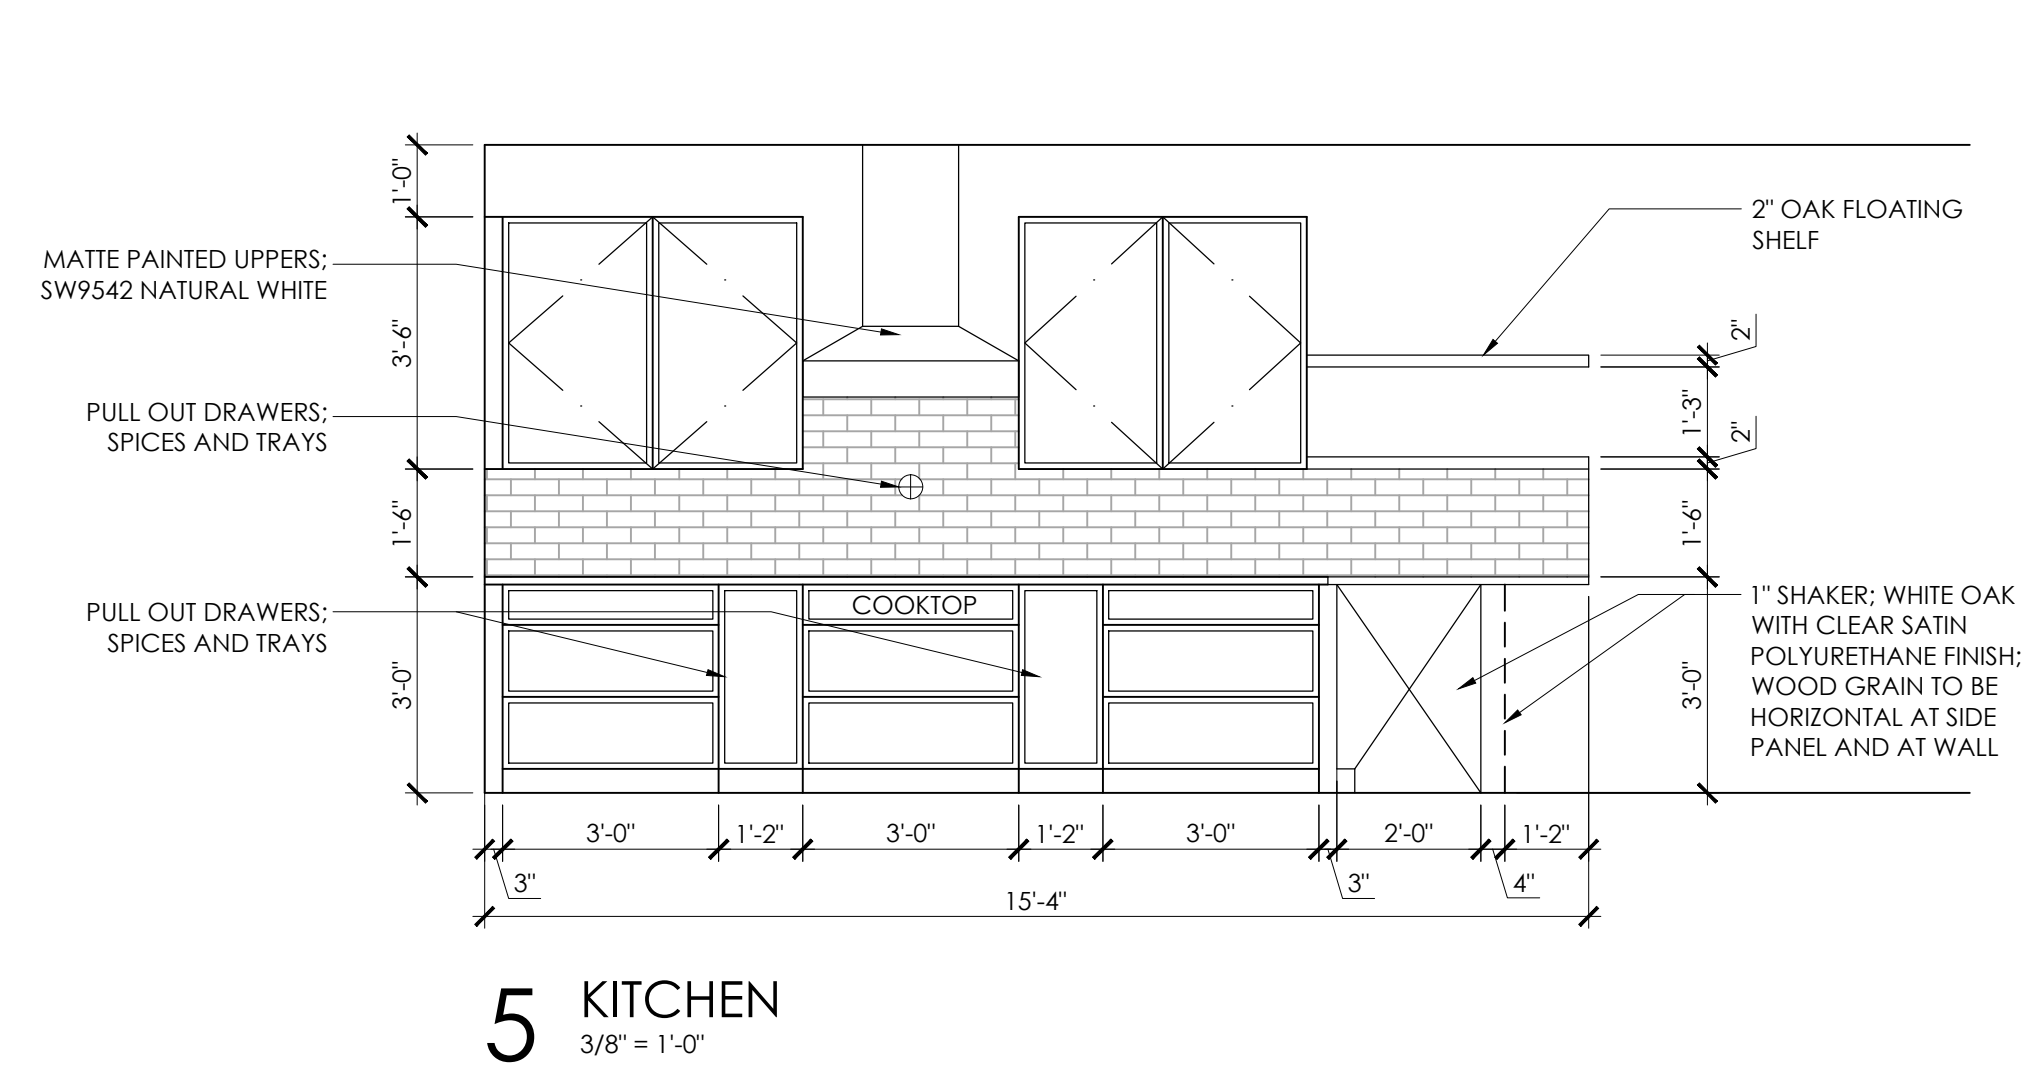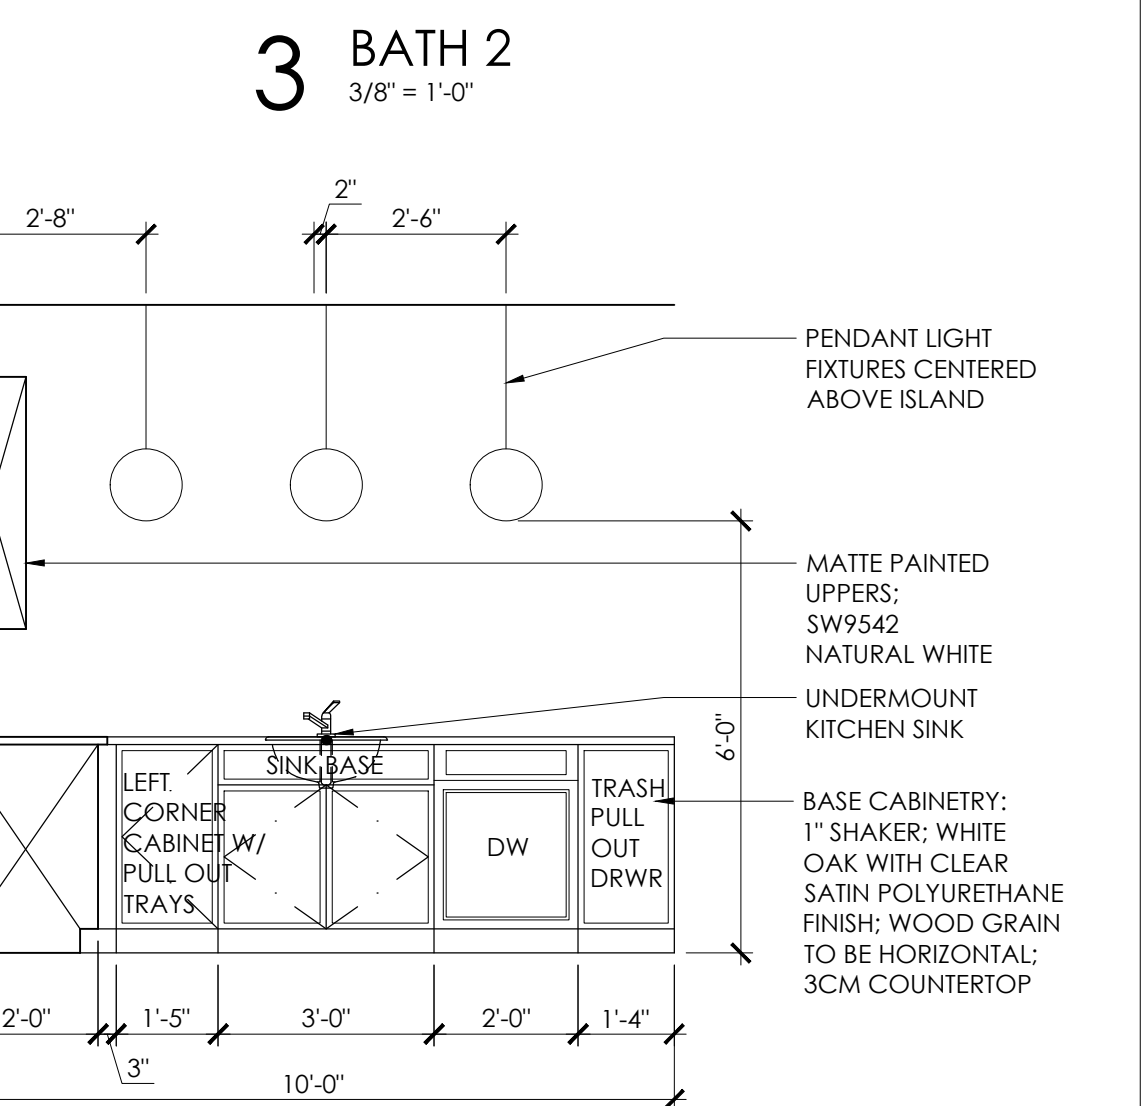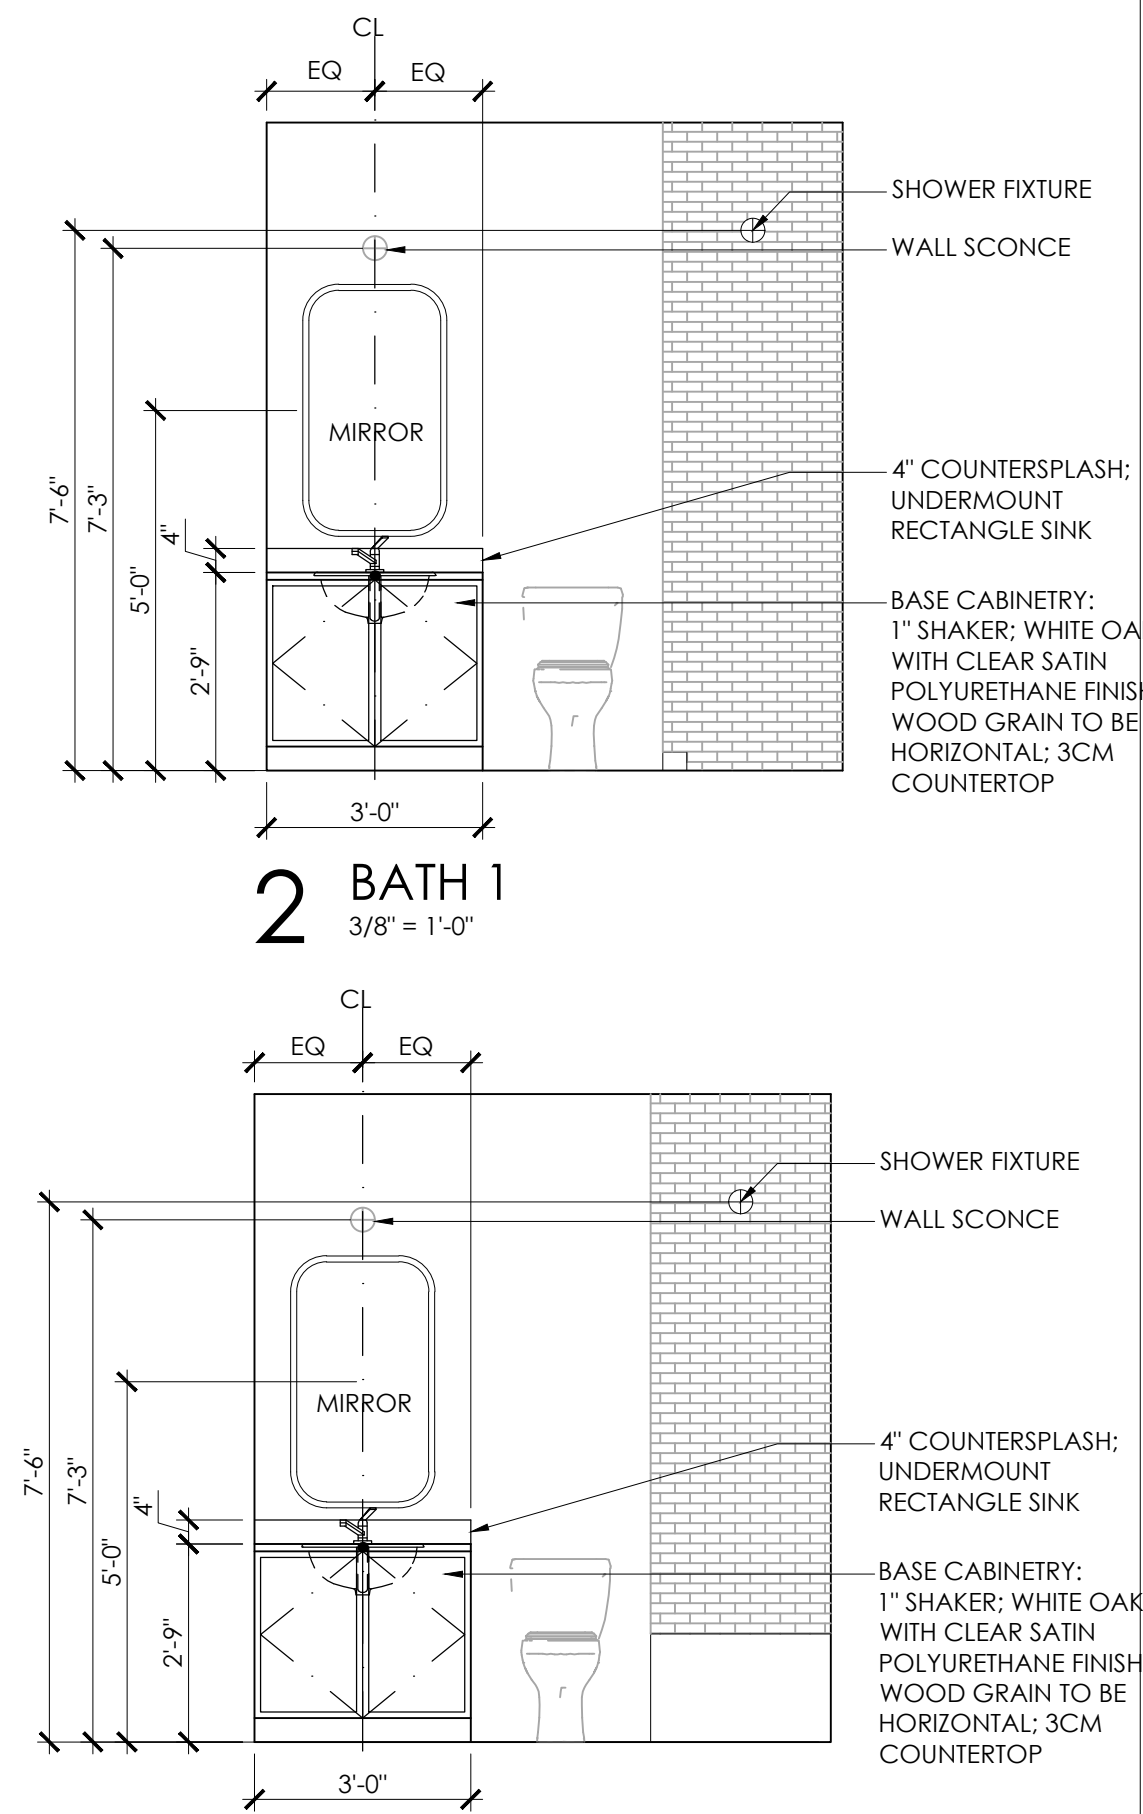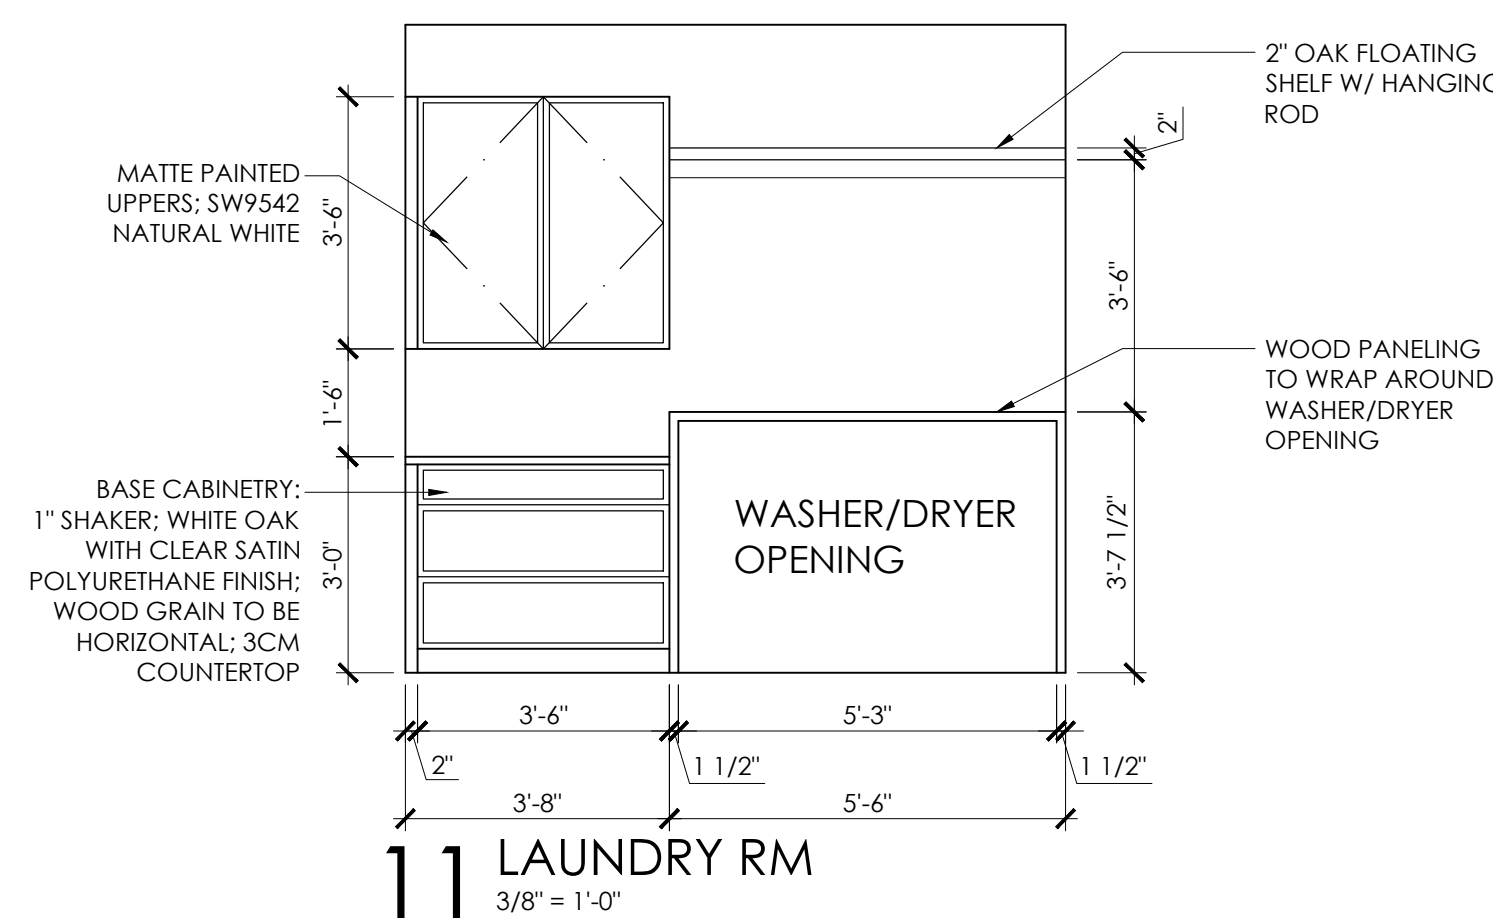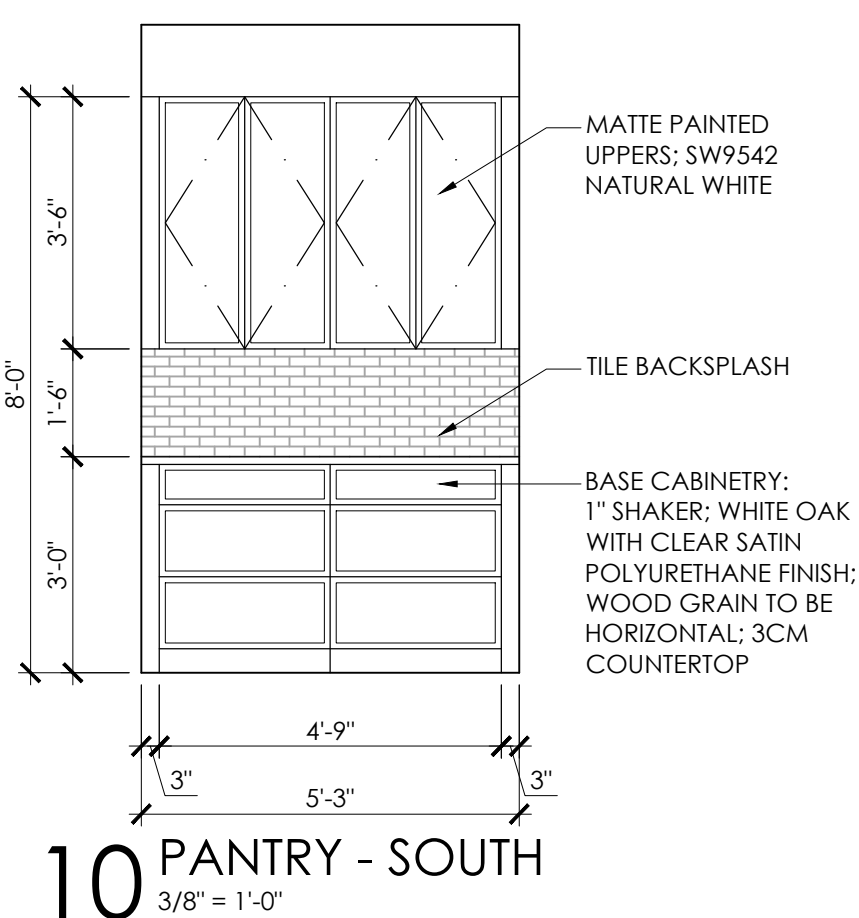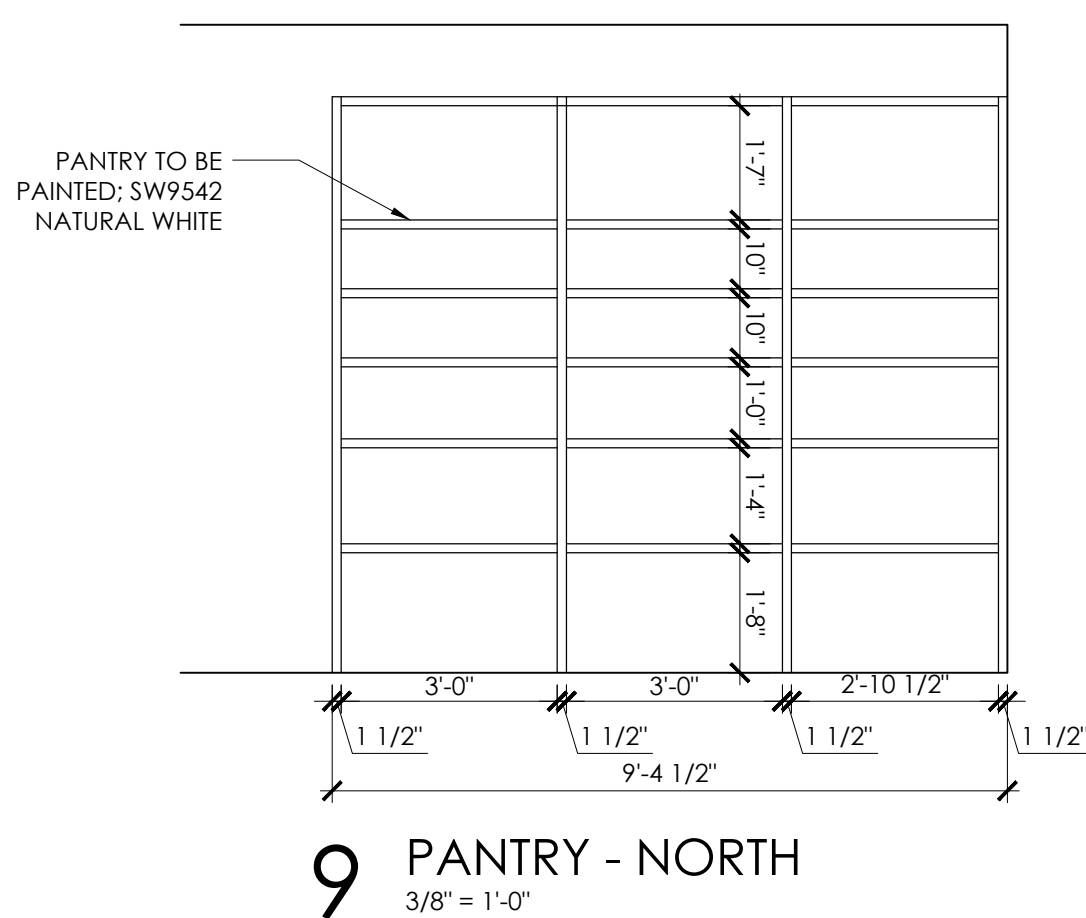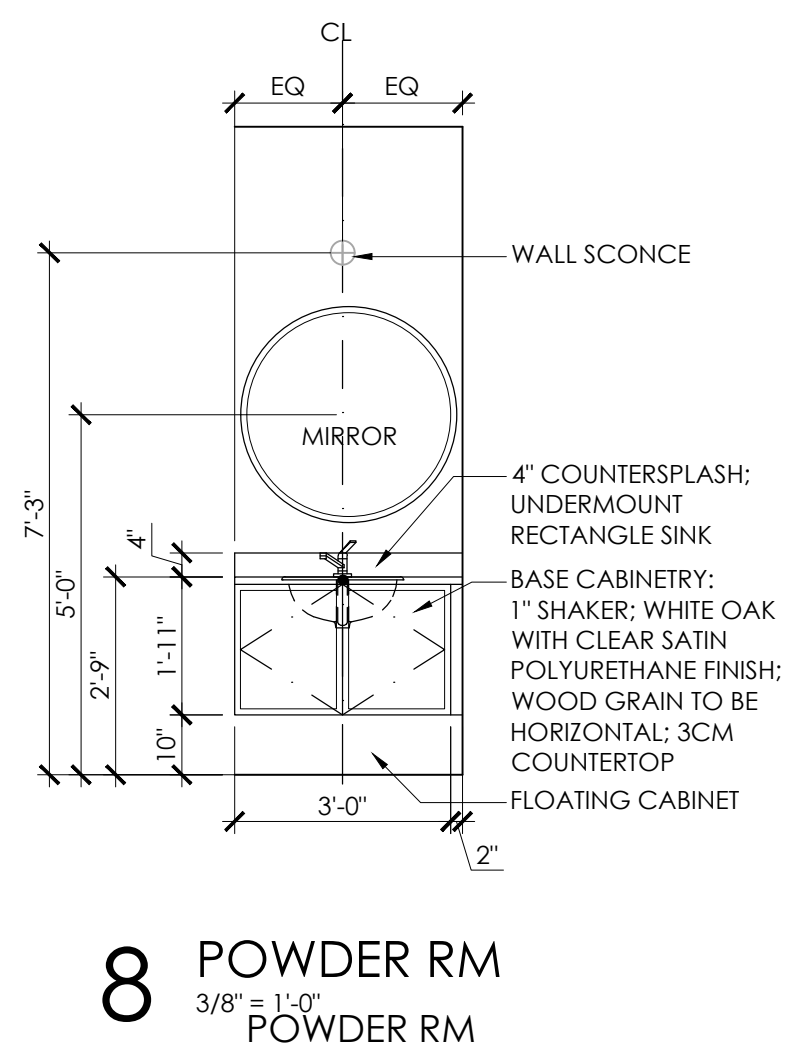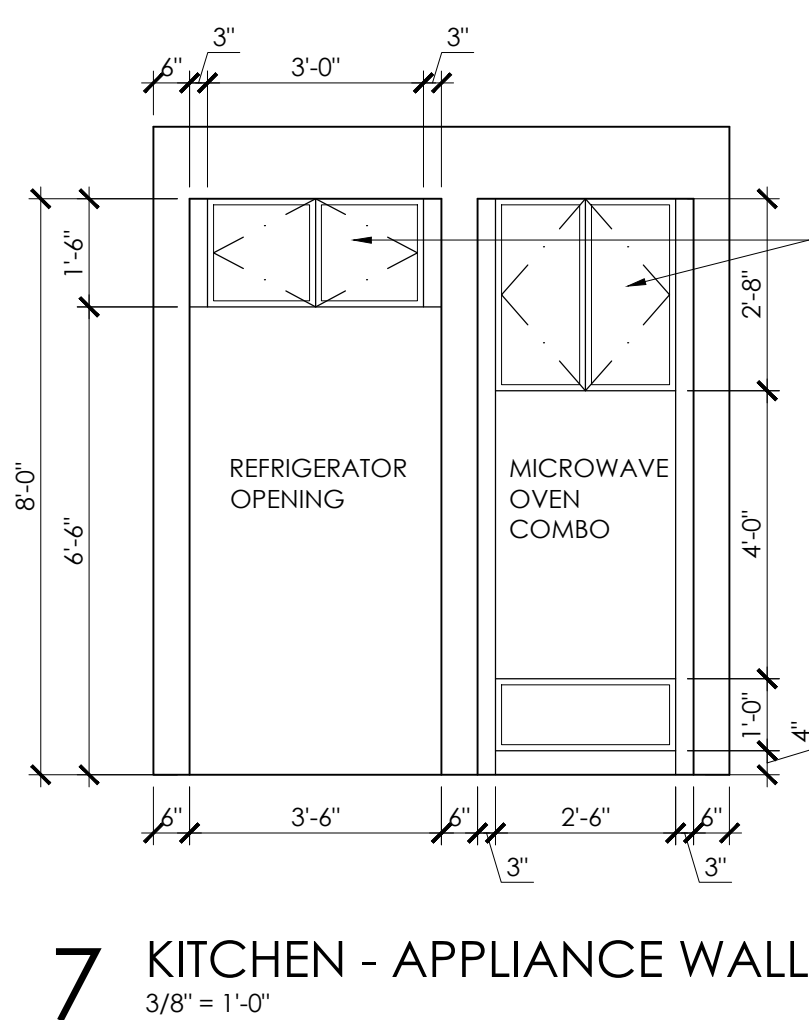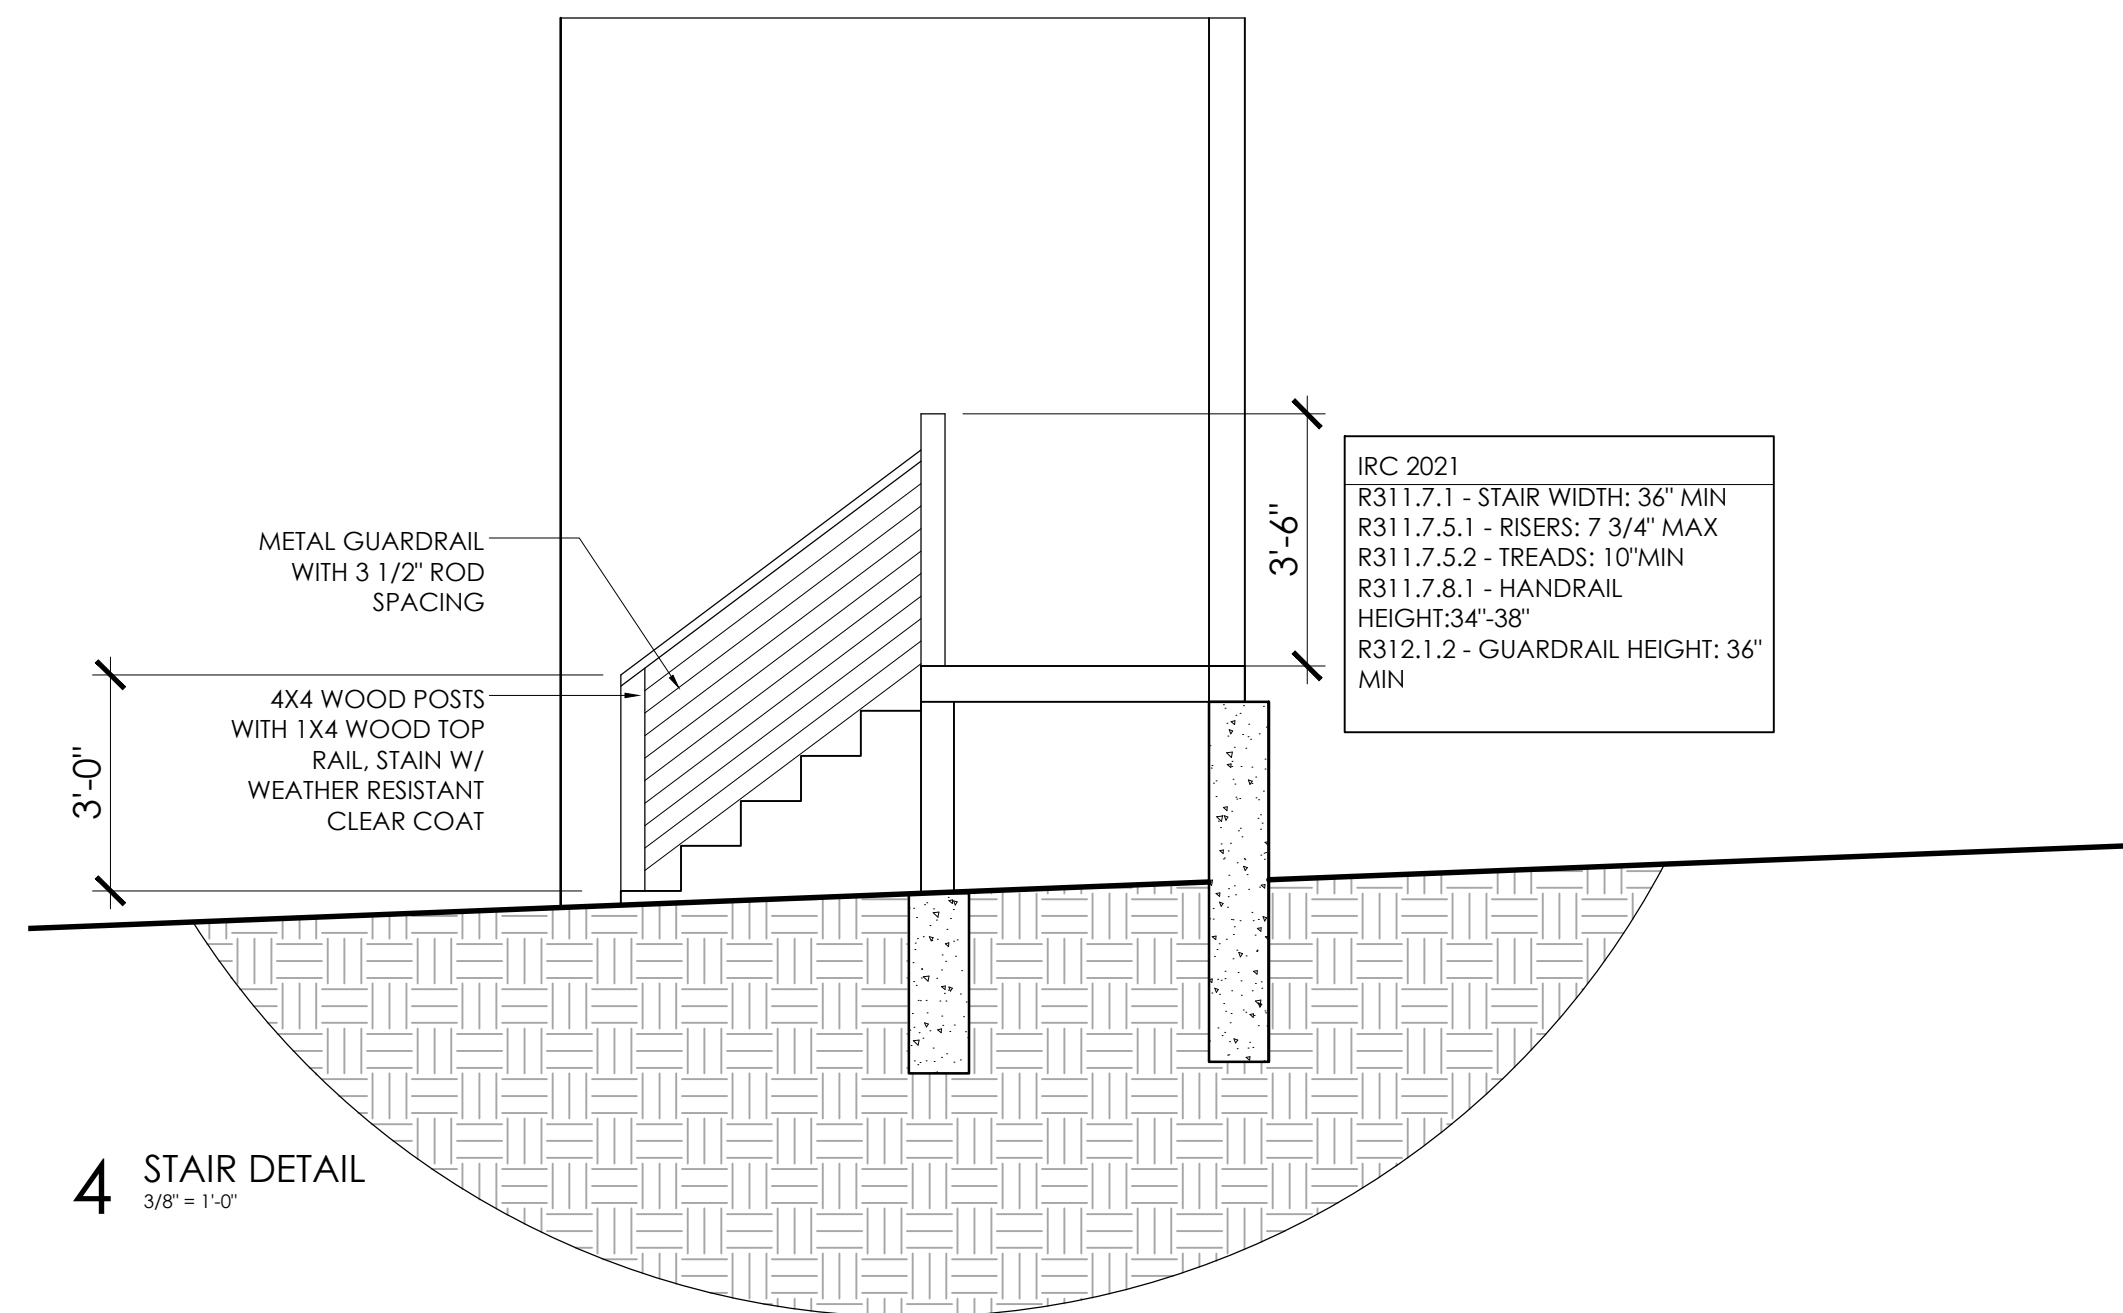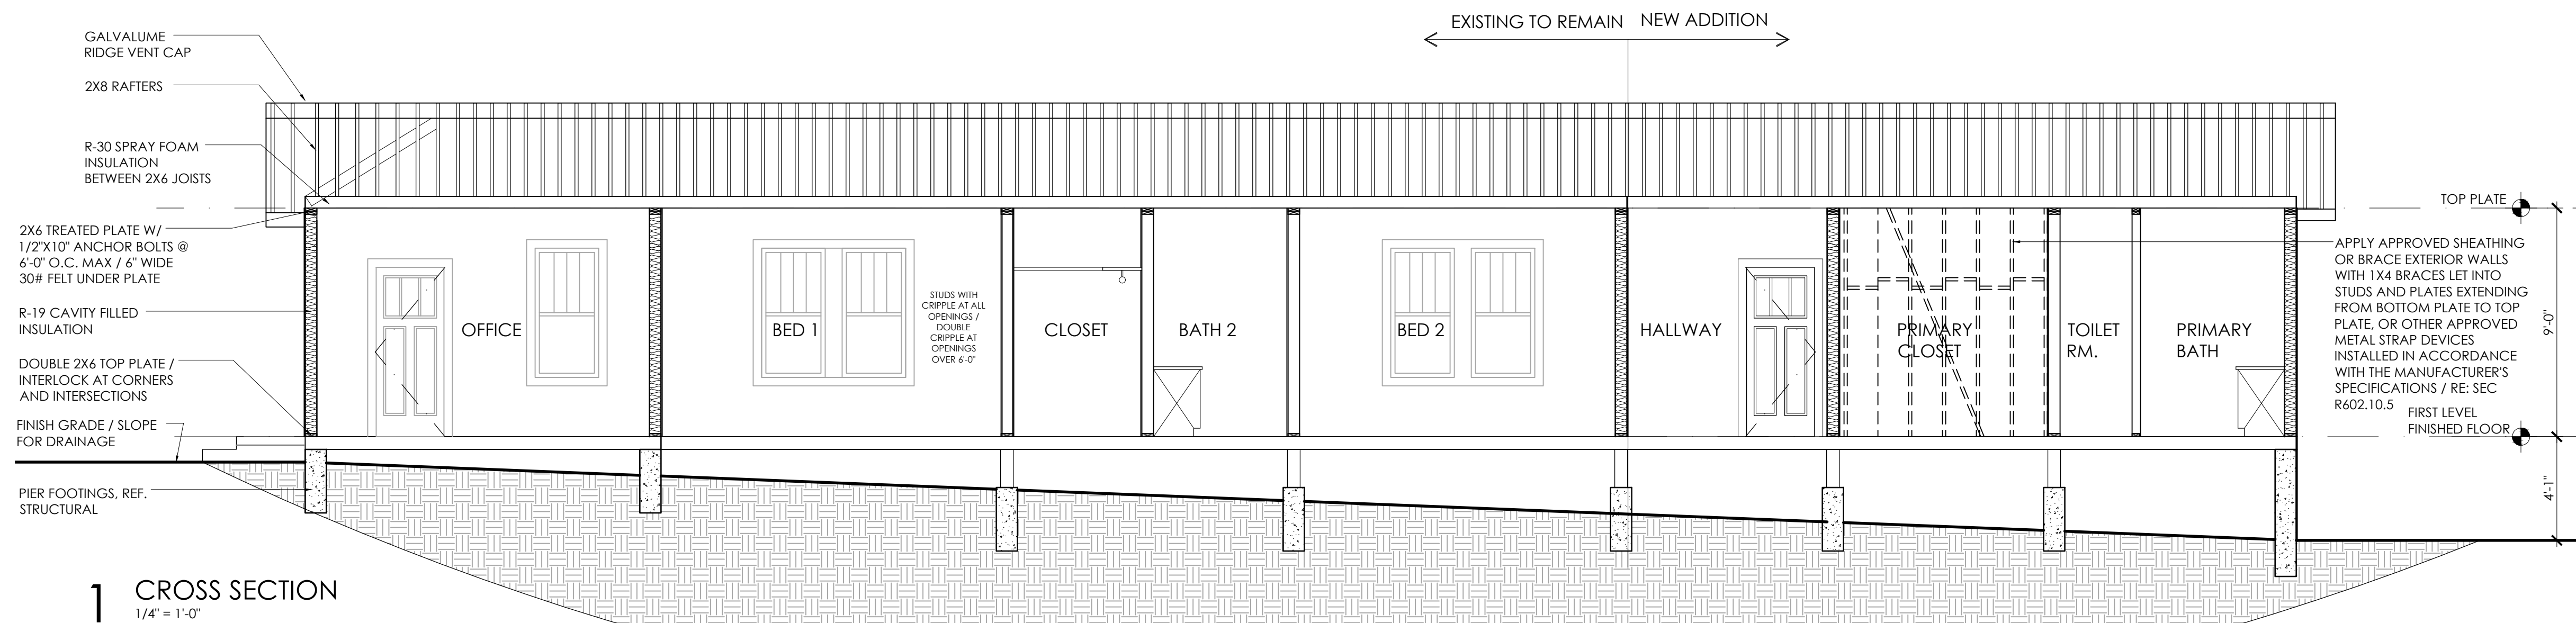

DATE: EXP. DATE:

CIRCA DESIGN

VOICE: (210) 421-8890

GENEVIE@CIRCADESIGNSA.COM

Huisache Remodel

370 E. Huisache Ave.
San Antonio, TX 78212

OWNER: Collin Stone
Brian Treusdell
Raul Resendiz

370 E Huisache Ave
San Antonio, TX 78212

PROJECT NUMBER: 26-Huisache Ave

CONSTRUCTION DOCS
ISSUED FOR PERMIT

NO.	DATE	DESCRIPTION OF ISSUE
-----	------	----------------------

THIS PLAN AND THE DESIGNS CONTAINED HEREIN ARE THE PROPERTY OF CIRCA DESIGN AND MAY NOT BE REPRODUCED, ALL OR IN PART, WITHOUT THE WRITTEN CONSENT FROM CIRCA DESIGN.

CIRCA DESIGN IS A DESIGN COMPANY, NOT AN ENGINEERING FIRM. WE DO NOT QUALIFY TO BE ONE NOR ARE WE LICENSED TO DESIGN STRUCTURAL FRAMING, WINDBRACING OR FOUNDATIONS. A LICENSED PROFESSIONAL ENGINEER SHOULD BE CONTRACTED AND CONSULTED IMMEDIATELY REGARDING FRAMING, WINDBRACING AND THE FOUNDATION DESIGNS. SHOULD AN ENGINEER'S SEAL BE PRESENT ON THESE DRAWINGS, THE ENGINEER OF RECORD SHALL BEAR ALL RESPONSIBILITY FOR THE STRUCTURE. WINDBRACING AND FOUNDATION DESIGNS FOR THIS PROJECT. CIRCA DESIGN IS NOT TO BE HELD RESPONSIBLE FOR THE STRUCTURAL DESIGN IN ANY WAY MATTER OR FORM IF ANY ISSUES OR PROBLEMS ARISE.

SHEET TITLE: Cross Section & Millwork

DATE: 4 May 2026

SHEET NUMBER: A5.01