

GENERAL NOTES



- A. PROVIDE HANDRAILS ON ALL STAIRS / STEPS WITH AT LEAST 2 RISERS PER I.R.C. SEC. R315
B. INSTALL LEVER HANDLES ON ALL DOORS AND PLUMBING FIXTURES

KEYNOTES

1. 2x4 WOOD STUD FRAMING @ 16" O.C. SHOWN
2. TYPICAL 4" x 6" COLUMN FOR ROOF STRUCTURE ABOVE / RE. STRUCTURAL
3. UNSEALED CONCRETE SLAB THROUGHOUT CARPORT

LEGEND

- ===== EXTERIOR WALL / REFER TO ELEVATIONS
----- OVERHEAD CONSTRUCTION
DK 7'-0" X 7'-0" DOOR TYPE AND DIMENSION-REF. A5.01

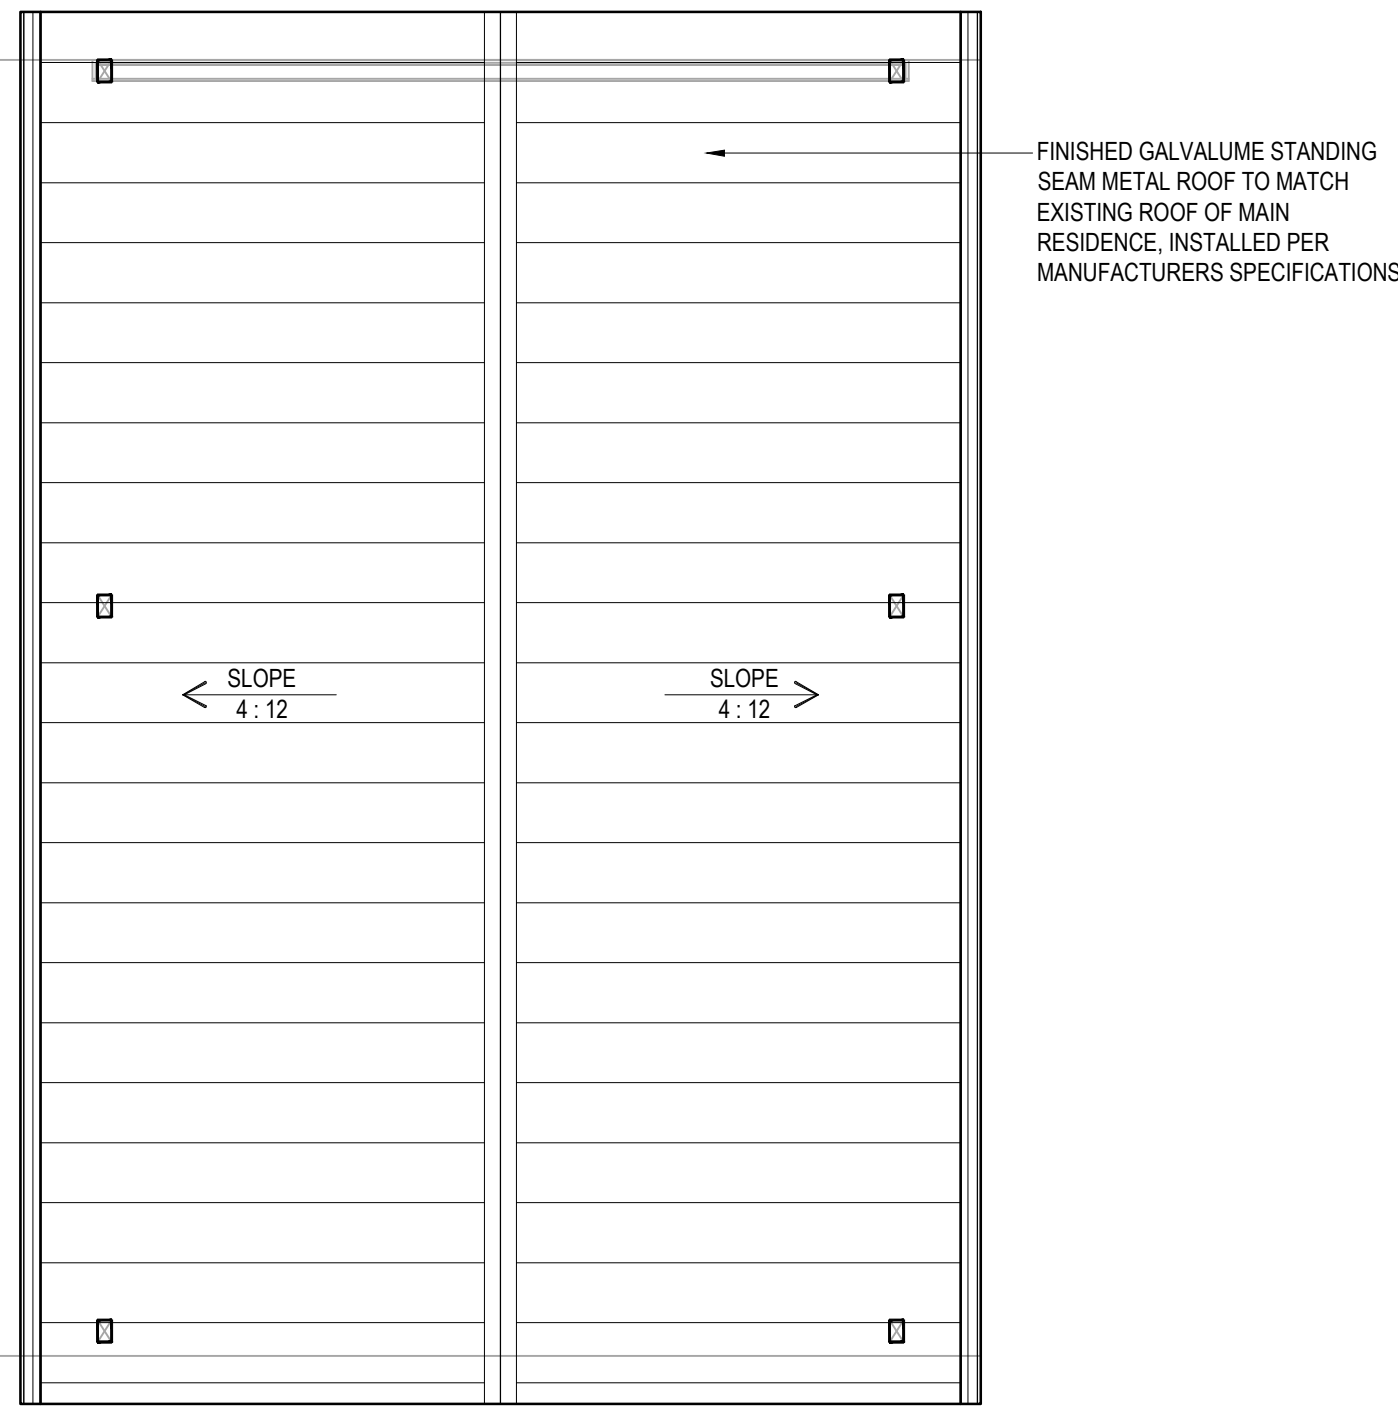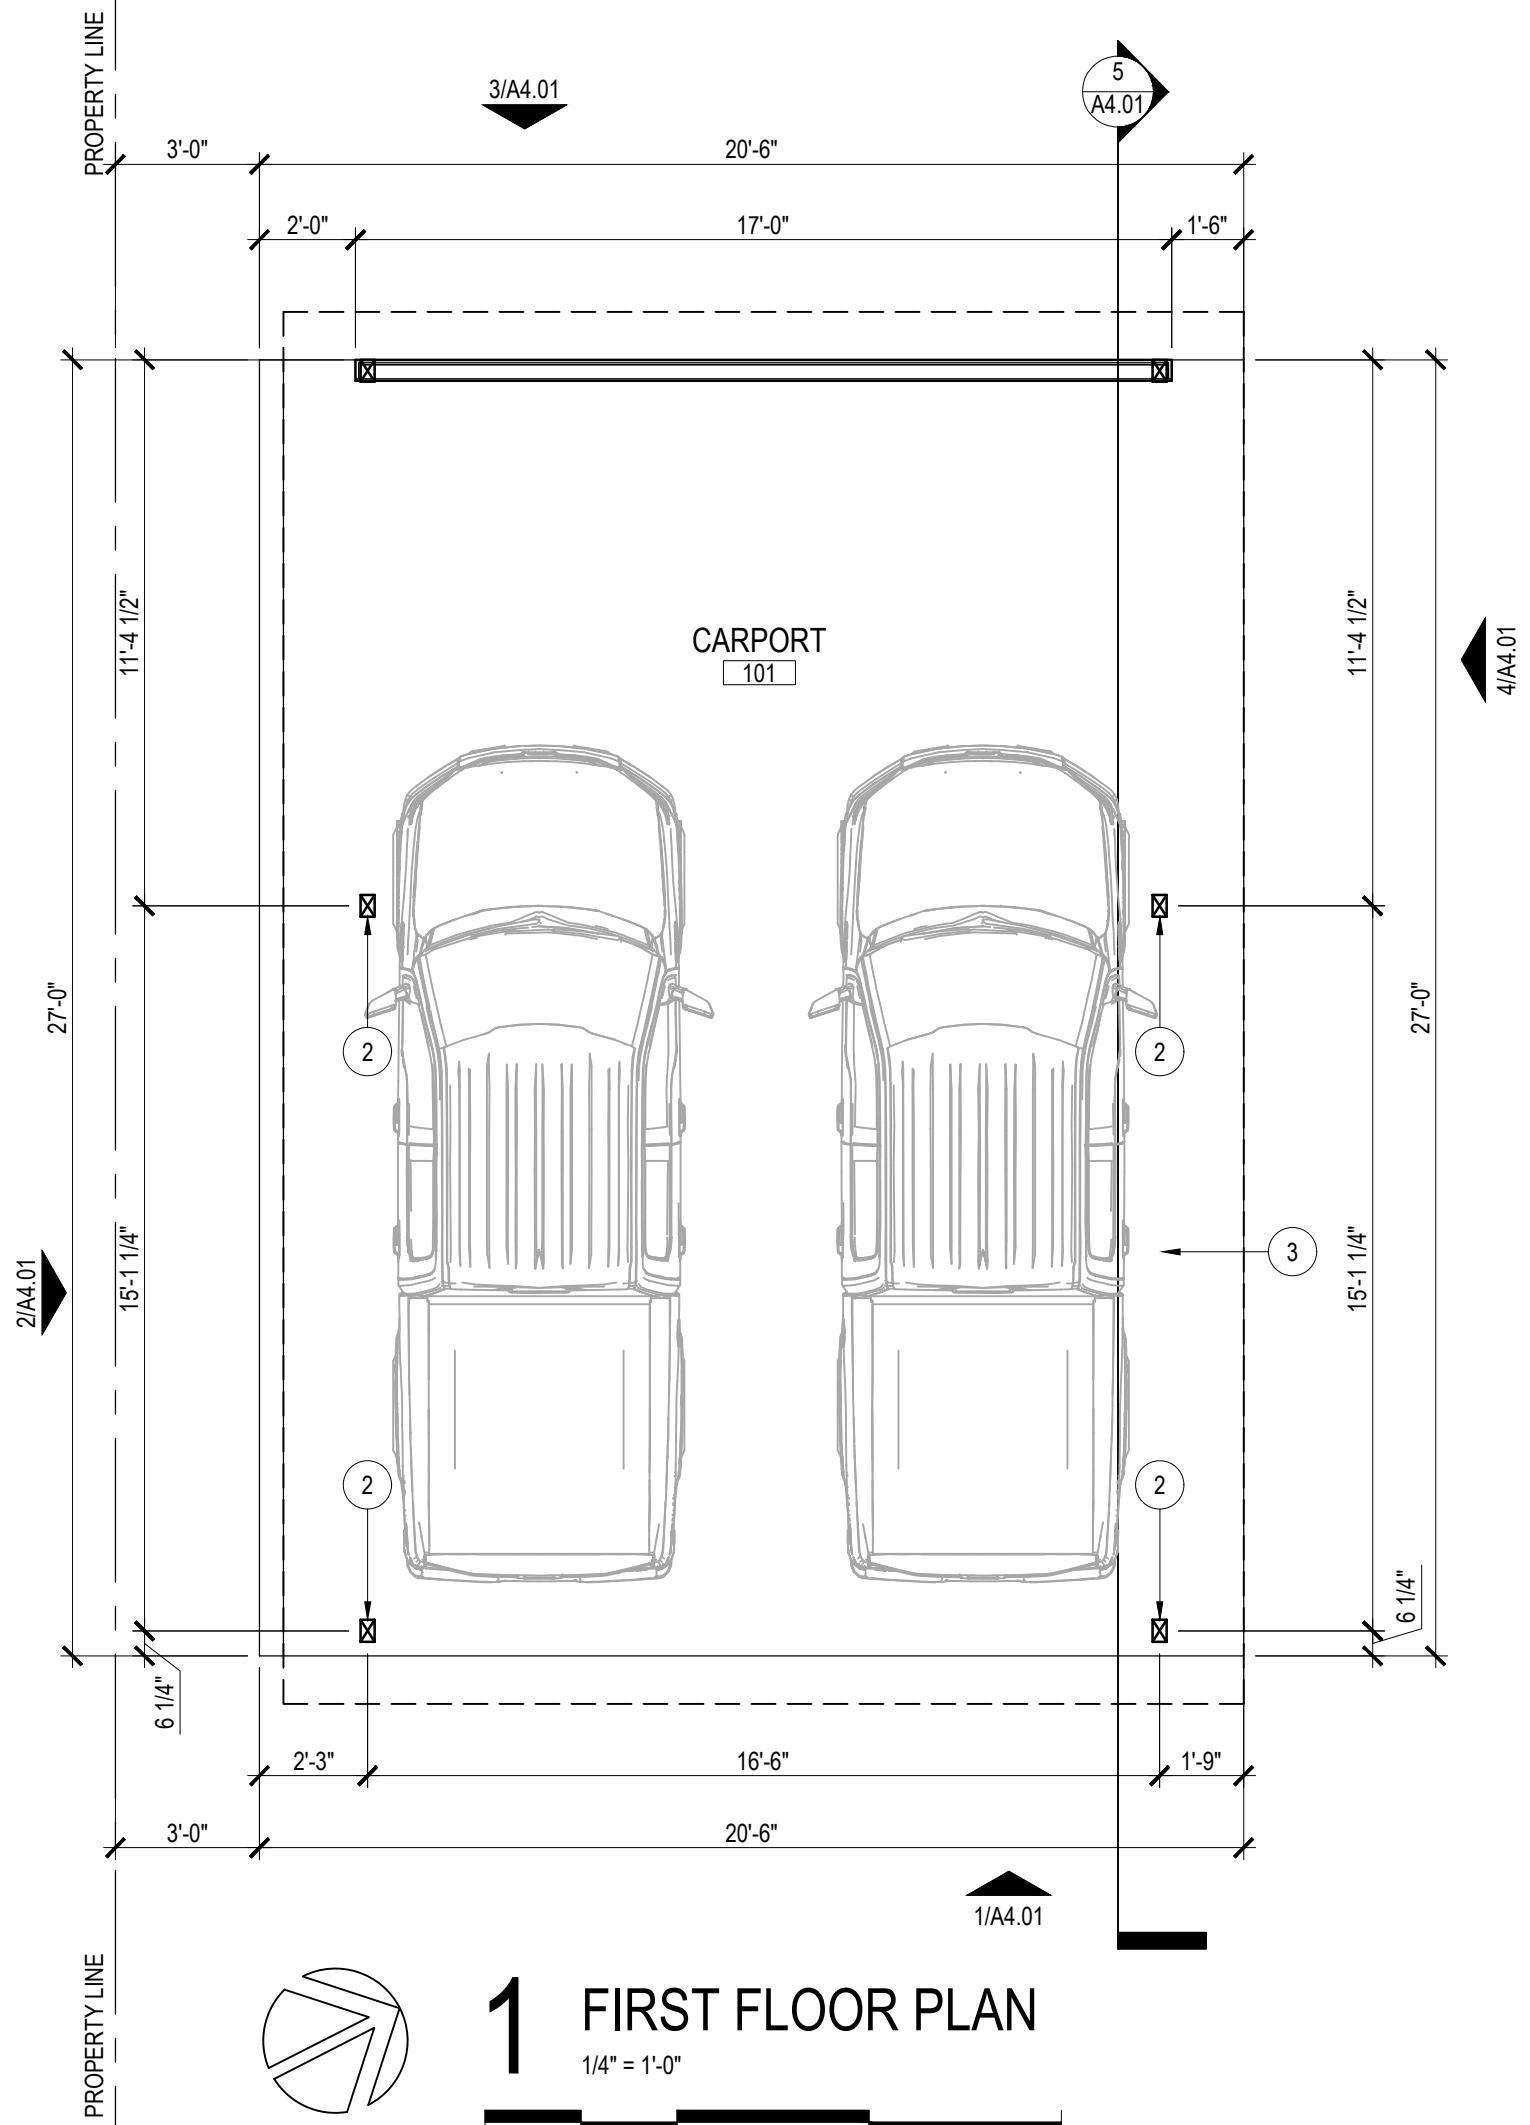


RCP LEGEND

- HARDIE BOARD SOFFIT, SLOPED

ELECTRICAL LEGEND

- LIGHT / POWER SWITCH
--- 3-WAY SWITCH
--- CURRENT LINE
○ WALL SCONCE
○ SURFACE MOUNTED LIGHT FIXTURE
○ 20 AMP, 120V, SINGLE PHASE DUPLEX RECEPTACLE 1PH-3W
○ WP GFCI DUPLEX RECEPTACLE / GROUND FAULT INTERRUPTING
* WATERPROOF COVER FOR EXTERIOR OUTLETS

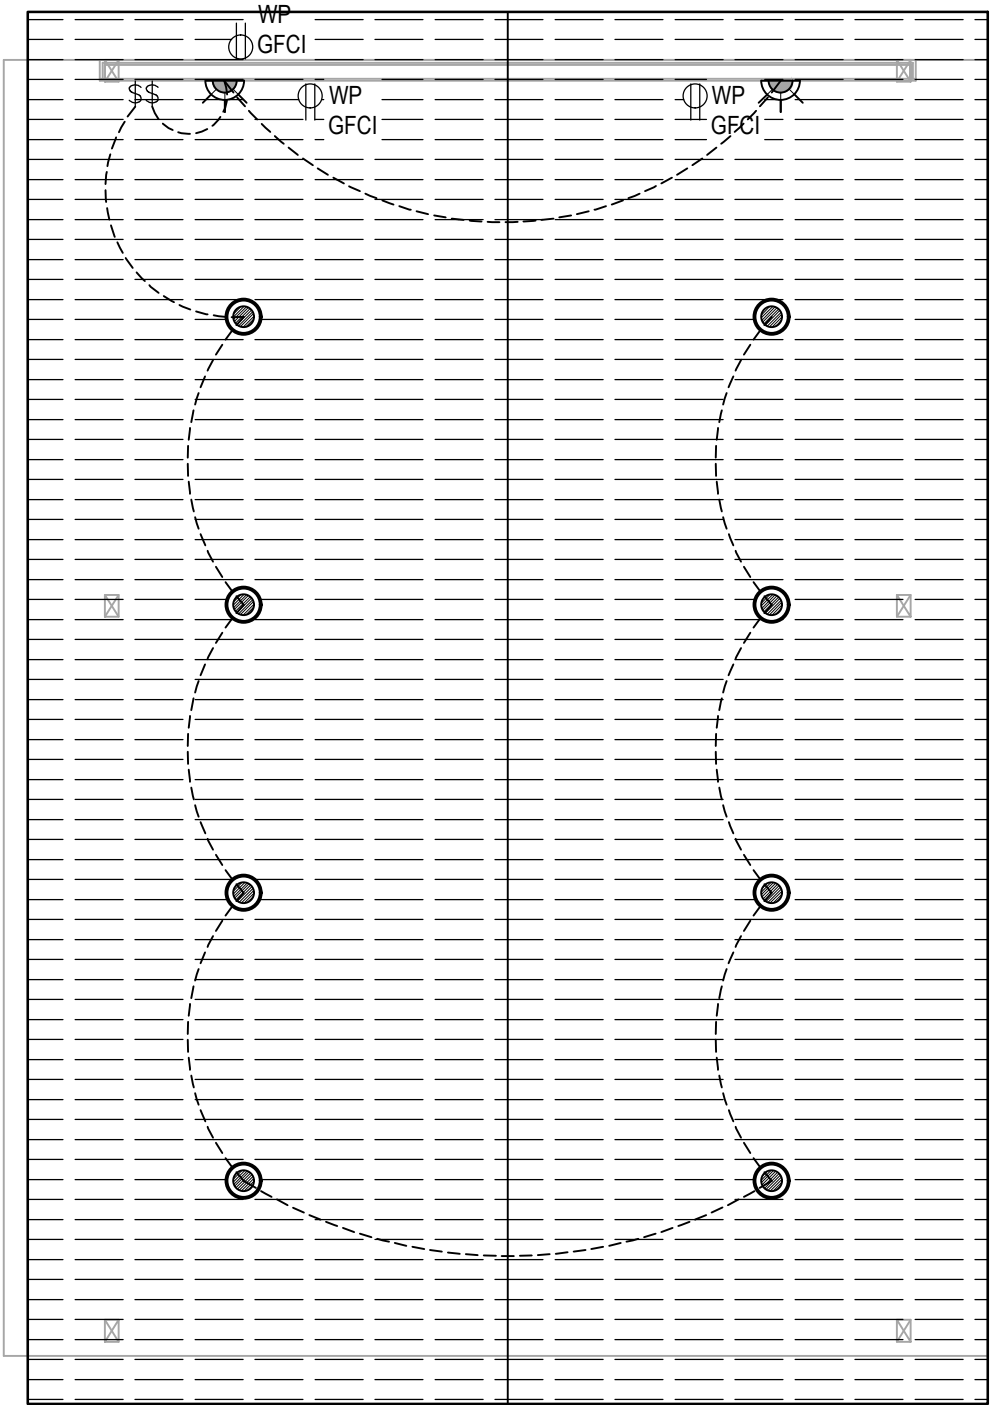

ALL RIGHTS RESERVED

smain339@gmail.com

(210) 365-3246

A CUSTOM CARPORT
FOR

MR. AND MRS. TIM BLAKE

115 QUEENS CRESCENT SAN ANTONIO, TX 78212

143 FURR DRIVE

SAN ANTONIO, TEXAS 78201

SHEET TITLE:
Floor Plan
Roof Plan

JOB NO.
2024-12

DRAWN BY:
S.R.M.

DATE:
31 July 2026

SHEET NUMBER

A2.01